




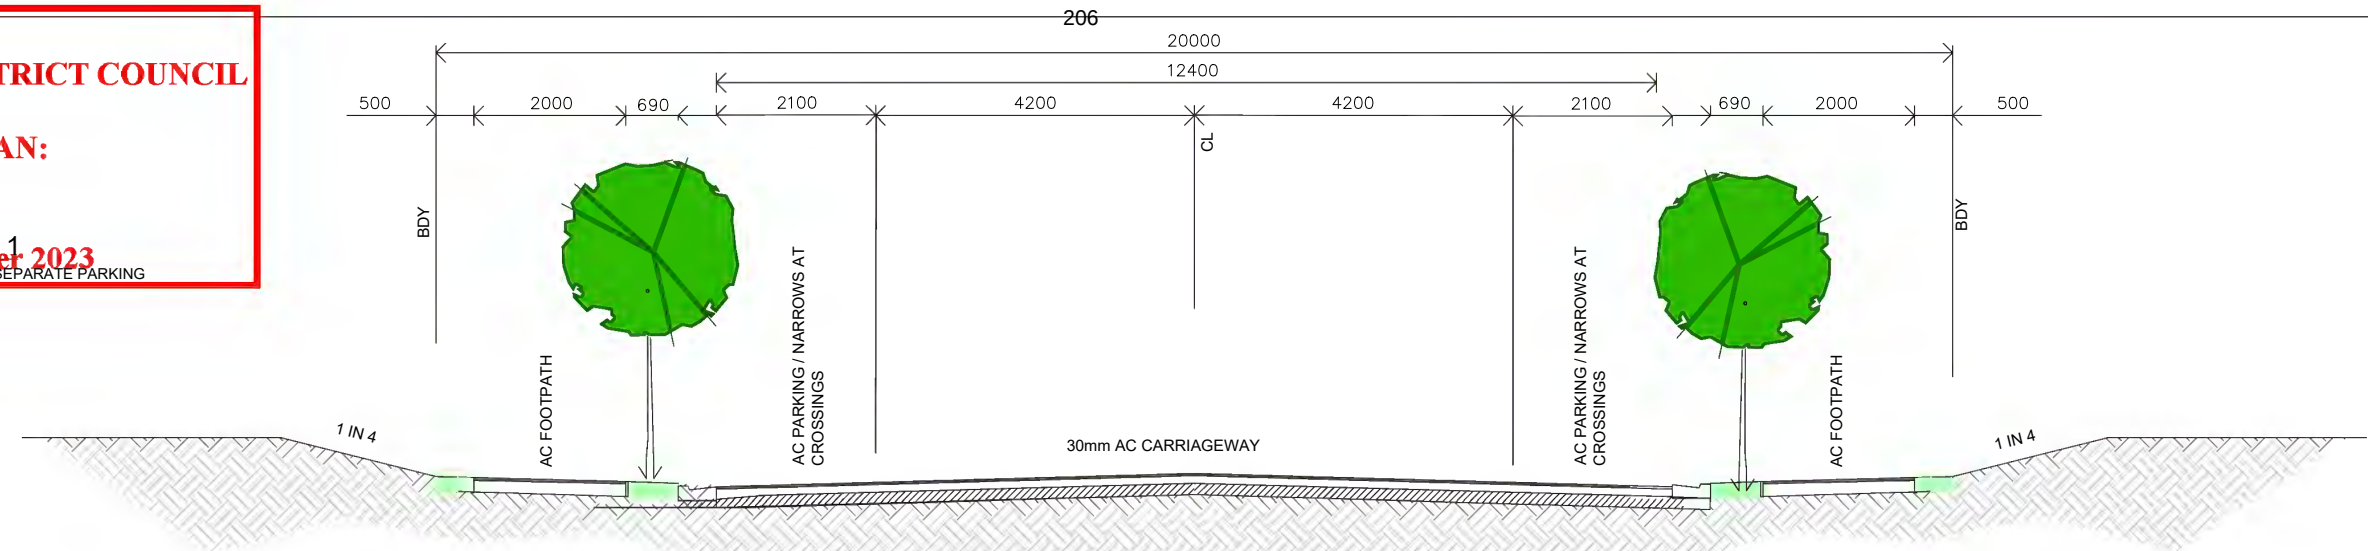

ROAD 3
2 X 3.6m MOVEMENT & 2 X SEPARATE PARKING

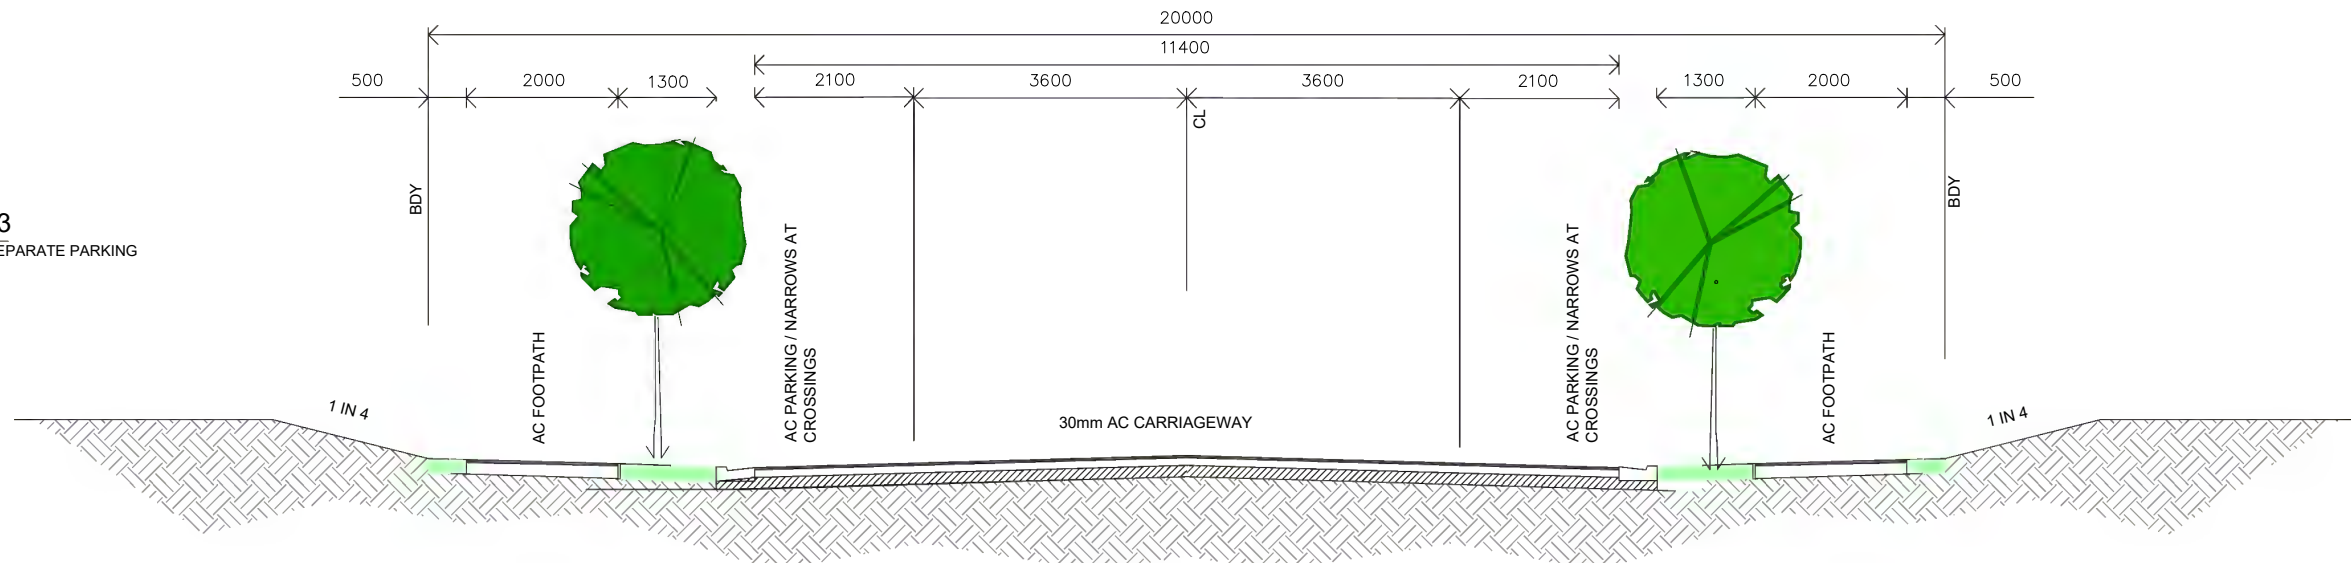

ROAD 2
2 X 3.0m MOVEMENT & 1 X SEPARATE PARKING

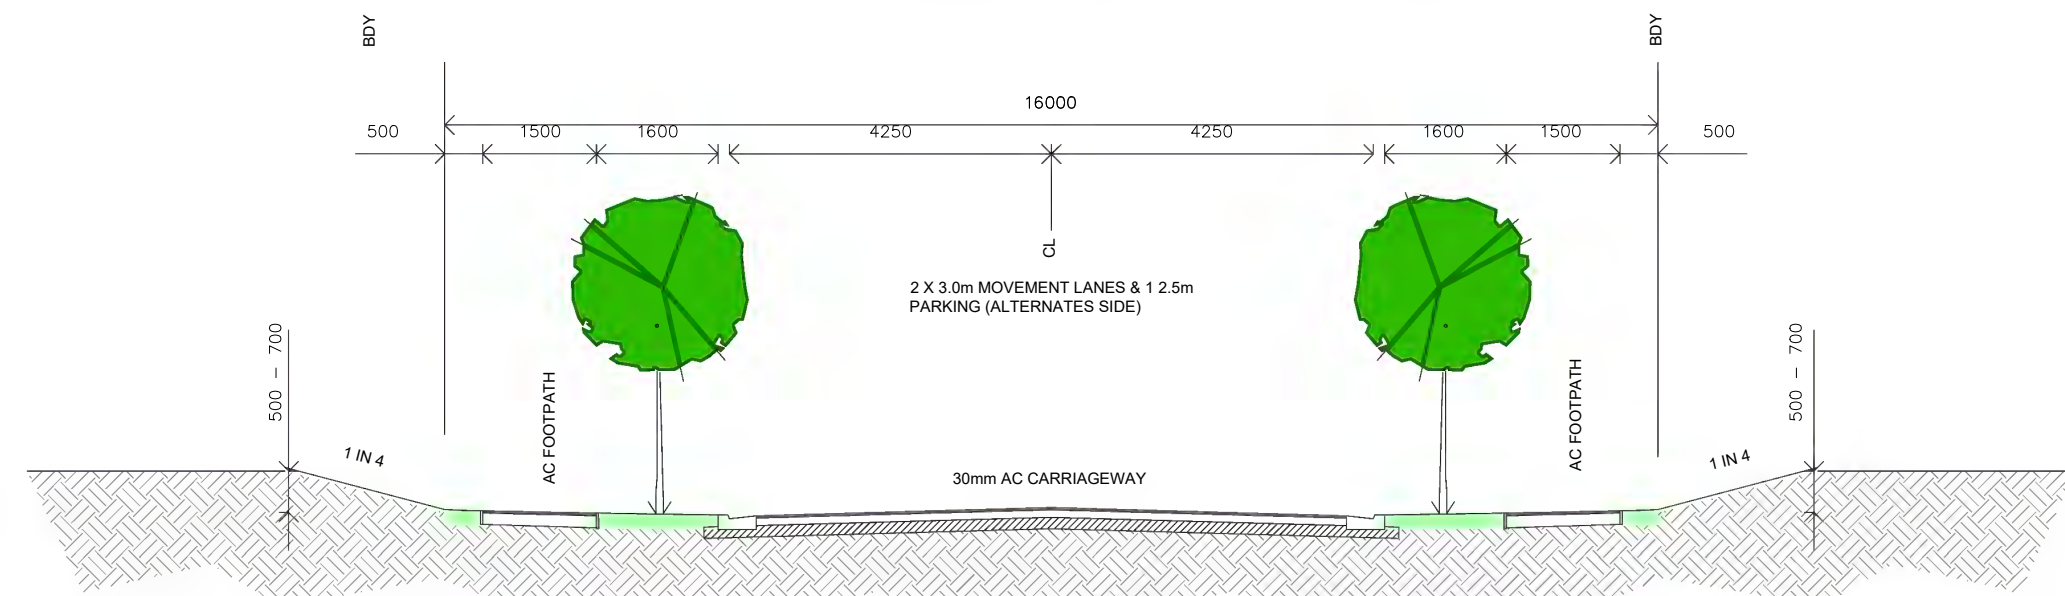

FOR CONSENT 10.08.2023

Clark Fortune McDonald & Associates
Licensed Cadastral Surveyors - Land Development - Planning Consultants
309 Lower Shotover Road, P.O. Box 553 Queenstown
Tel. (03)441-6044, Fax (03)442-1066, Email admin@cfma.co.nz
Shop 2, Otago House, 475 Moray Place, P.O. Box 5960
Tel. (03)470-1582, Fax (03)470-1583, Email admin@cfma.co.nz

Rev.	Date	Revision Details	By
C	08.05.20	Update Road 2 width	BM
E	06.07.20	Update Road 1, 2 & 3 widths	BM
G	06.10.20	Update Road profiles	RB
H	19.01.21	Adjust Road 001 width to 3.6m	RB
O	02.08.22	ALTERNATIVE ROAD LAYOUT	RB
P	06.09.22	Changes following Traffic review	RB

**WOOLSHED ROAD DEVELOPMENT
TYPICAL ROAD SECTIONS**


Client	Surveyed	Date	Checked	Job No.	Drawing No.
HENLEY DOWNS FARM HOLDINGS LTD	-	-	-	12983	5 Sheet 004
	Drawn	Date	Checked	Scale	
RB	-	-	-	1:100 @ A3	
	Designed	Date	Checked	Datum & Level	Rev.
	-	-	-	NZGD2000 / MSL	P

QUEENSTOWN LAKES DISTRICT COUNCIL


APPROVED PLAN:
RM200615

Friday, 29 September 2023


ROADS 4 - 8
4.0m SHARED MOVEMENT / PARKING

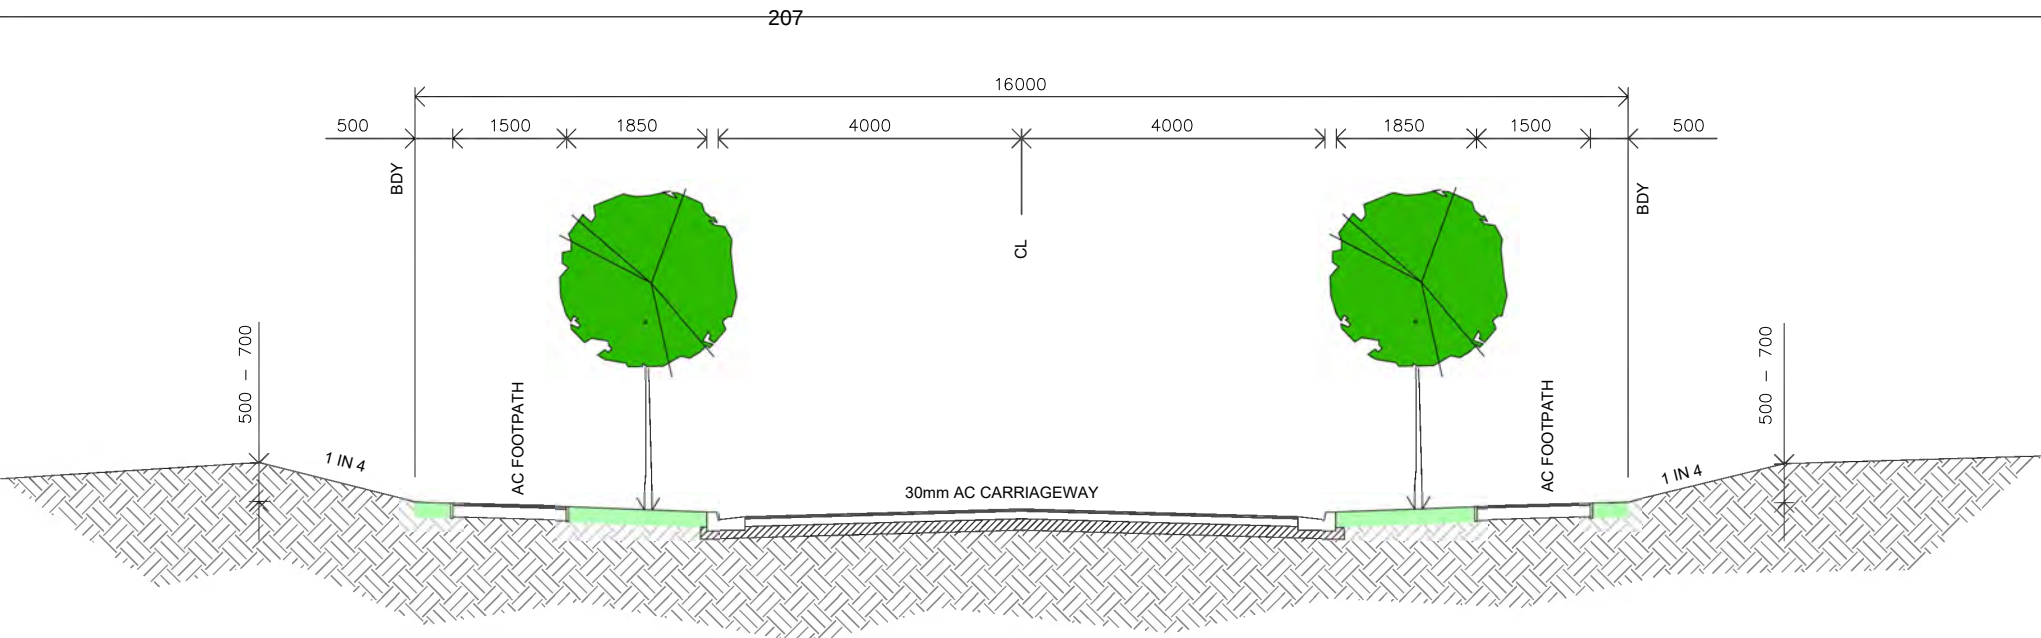

WOOLSHED ROAD - LINK TO SH6
UPGRADE OPTION IF NO SHA ROUNDABOUT
2 X 4.2m MOVEMENT & SHOULDER

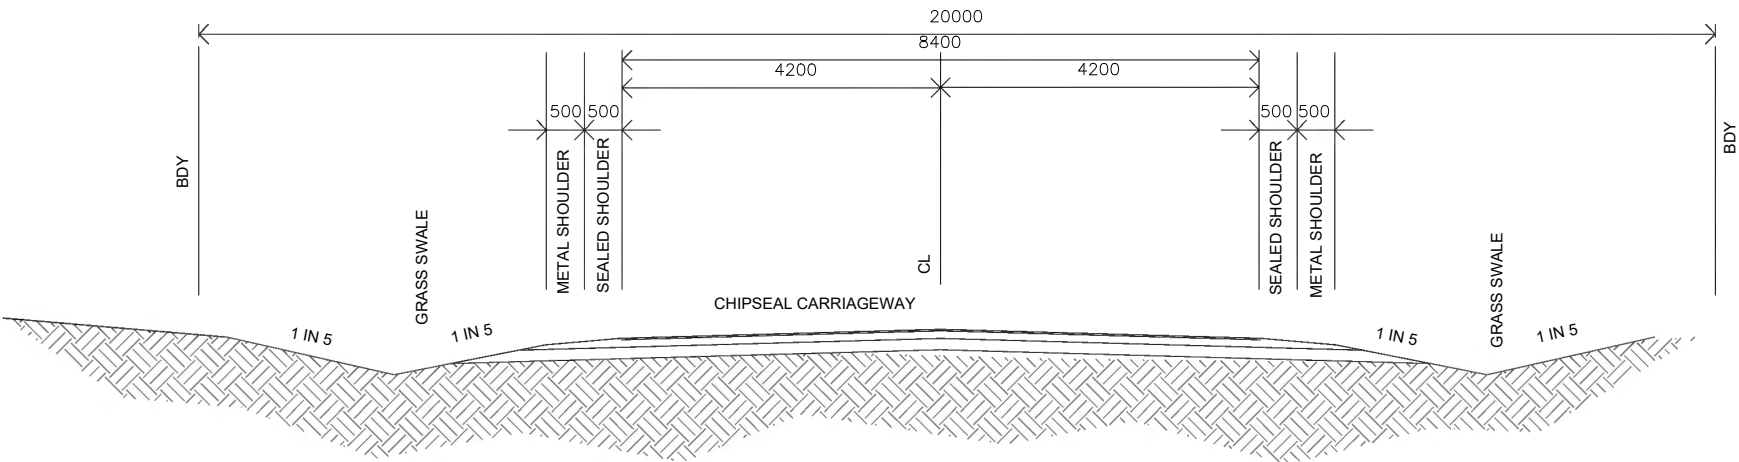

FUTURE NORTHERN CONNECTION 2 X 4.2m MOVEMENT

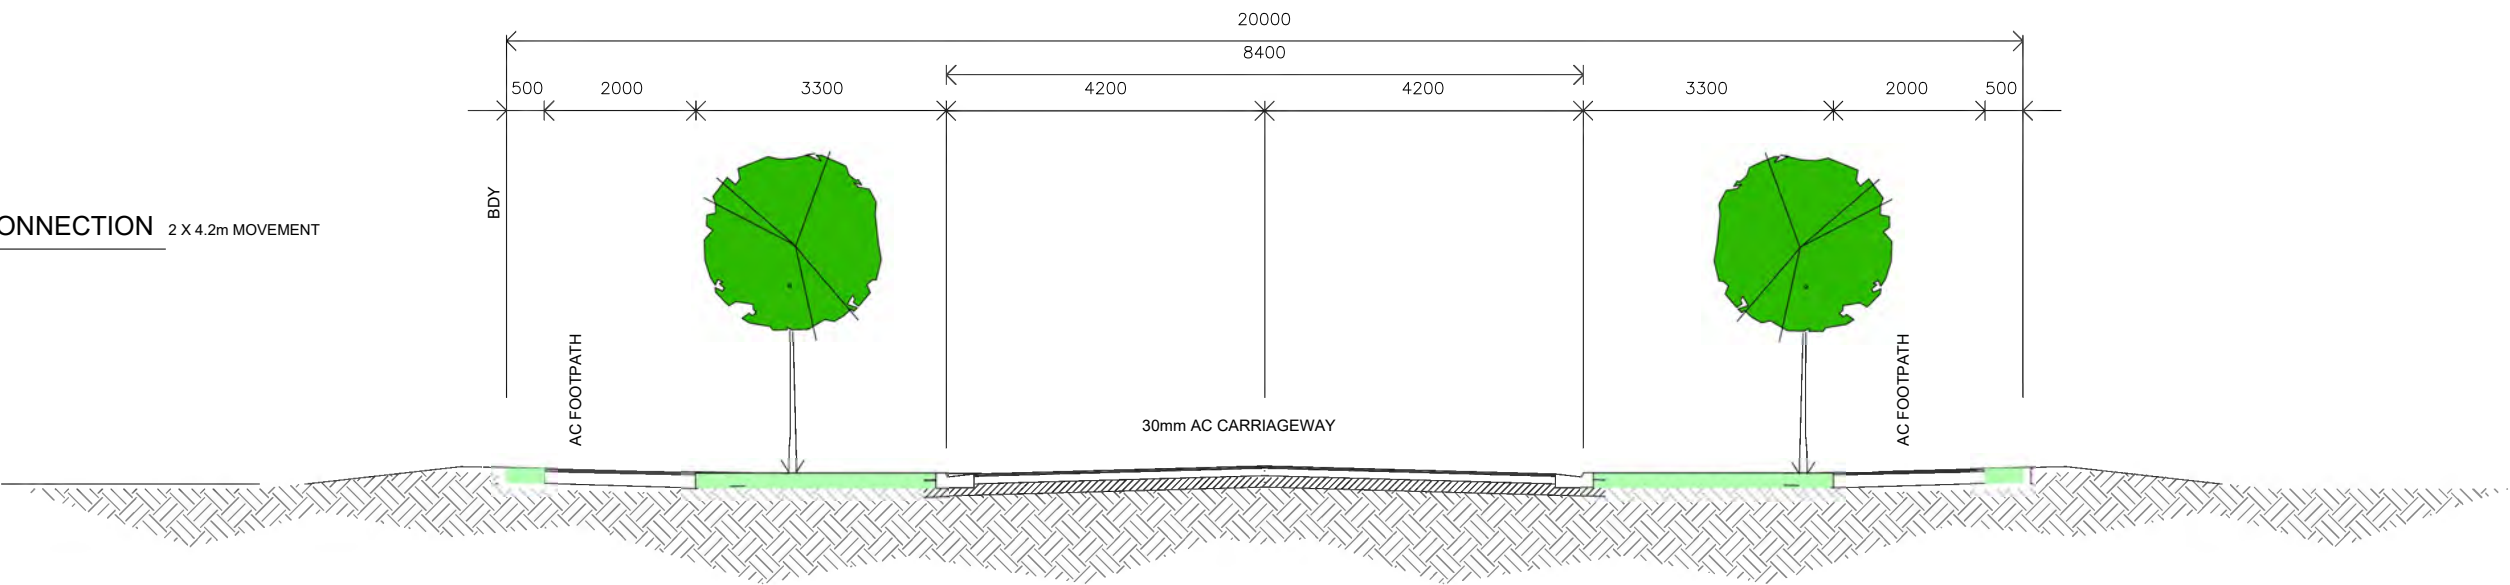

FOR CONSENT 10.08.2023

Clark Fortune McDonald & Associates
Licensed Cadastral Surveyors - Land Development - Planning Consultants
309 Lower Shotover Road, P.O. Box 553 Queenstown
Tel. (03)441-6044, Fax (03)442-1066, Email admin@cfma.co.nz
Shop 2, Otago House, 475 Moray Place, P.O. Box 5960
Tel. (03)470-1582, Fax (03)470-1583, Email admin@cfma.co.nz

Rev.	Date	Revision Details	By
C	08.05.20	Update Road 2 width	BM
E	06.07.20	Update Road 1, 2 & 3 widths	RB
G	06.10.20	Update Road profiles	RB
H	19.01.21	Update Woolshed Rd to 4.2m lanes	RB
P	06.09.22	Changes following Traffic review	RB

WOOLSHED ROAD DEVELOPMENT TYPICAL ROAD SECTIONS

Client	Surveyed	Date	Checked	Job No.	Drawing No.
HENLEY DOWNS FARM HOLDINGS LTD	-	-	-	12983	5
					Sheet 005
	Drawn	Date	Checked	Scale	1:50.000 @ A1
	RB	-	-		1:100 @ A3
	Designed	Date	Checked	Datum & Level	Rev.
		-	-	NZGD2000 / MSL	P

LEGEND

MAJOR (2.0m)
MINOR (0.5m)

FOR CONSENT 10.08.2023



Clark Fortune McDonald & Associates

Licensed Cadastral Surveyors - Land Development - Planning Consultants

309 Lower Shotover Road, P.O.Box 553 Queenstown

Tel. (03)441-6044, Fax (03)442-1066, Email admin@cfma.co.nz

Shop 2, Otago House, 475 Moray Place, P.O. Box 5960

Tel. (03)470-1582, Fax (03)470-1583, Email admin@cfma.co.nz

Rev.	Date	Revision Details	By
E	01.07.20	Update sewer crossing location & level	RB
F	07.07.20	Update Rising main alignment & add future stub	RB
I	17.02.21	Vehicle turning paths	JJ
J	08.03.21	Amend kerbs and intersections for turning	JJ
K	06.05.21	Amend Future connection and lot locations	NT
P	06.09.22	Changes following Traffic review	RB
Q	10.08.23	Adjust bus stops	RB

WOOLSHED ROAD DEVELOPMENT
DRAINAGE LAYOUT

HENLEY DOWNS FARM HOLDINGS LTD

Notes:
All dimensions shown are in meters unless shown otherwise.
Any person using Clark Fortune McDonald drawings and other data accepts the risk of:
Using the drawings and other data in electronic form without requesting and checking them for accuracy against the original hard copy versions.
Ensuring the information is the most recent issue.
Copyright on this drawing is reserved.

Surveyed	Date	Checked	Scale	Job No.	Drawing No.
				12983	5
Drawn	Date	Checked	Scale		Sheet 006
RB				1:2000 @ A3	
Designed	Date	Checked	Datum & Level	Rev.	
			NZGD2000 / MSL	Q	

QUEENSTOWN LAKES DISTRICT COUNCIL

APPROVED PLAN:
RM200615

Friday, 29 September 2023



ROAD 2
AUSTROAD SINGLE UNIT TRUCK/BUS (12.5m)
RADIUS 12.5m

ROAD 7 BEND
AUSTROAD SERVICE VEHICLE (8.8m)
RADIUS 9.0m

FOR CONSENT 10.08.2023

0.5m CLEARANCE FROM VEHICLE



Clark Fortune McDonald & Associates
Licensed Cadastral Surveyors - Land Development - Planning Consultants
309 Lower Shotover Road, P.O. Box 553 Queenstown
Tel. (03)441-6044, Fax (03)442-1066, Email admin@cfma.co.nz

Shop 2, Otago House, 475 Moray Place, P.O. Box 5960
Tel. (03)470-1582, Fax (03)470-1583, Email admin@cfma.co.nz

Rev.	Date	Revision Details	By
C	08.05.20	Update with revised lots & reduce road 2 width	RB
D	25.05.20	Add sewer easement & update Fluent sw channel	RB
E	01.07.20	Update sewer crossing location & level	RB
F	07.07.20	Update Rising main alignment & add future stub	RB
I	17.02.21	Vehicle turning paths	JJ
J	08.03.21	Amend kerbs and intersections for turning	JJ
P	06.09.22	Changes following Traffic review	RB

WOOLSHED ROAD DEVELOPMENT
VEHICLE TURNING PATHS
AUSTROADS SINGLE UNIT TRUCK/BUS (12.5m)

Notes:

- All dimensions shown are in meters unless shown otherwise.
- Any person using Clark Fortune McDonald drawings and other data accepts the risk of:
- Using the drawings and other data in electronic form without requesting and checking them for accuracy against the original hard copy versions.
- Ensuring the information is the most recent issue.
- Copyright on this drawing is reserved.

Client	Surveyed	Date	Checked	Job No.	Drawing No.
HENLEY DOWNS FARM HOLDINGS LTD	-	-	-	12983	5
					Sheet 007
	Drawn	Date	Checked	Scale	
RB	-	-	-	1:400 @ A3	
	Designed	Date	Checked	Datum & Level	Rev
	-	-	-	NZGD2000 / MSL	P


QUEENSTOWN LAKES DISTRICT COUNCIL
ROUNDABOUT TURN
AUSTROAD SINGLE UNIT TRUCK/BUS (12.5m)
RADIUS 12.5m

APPROVED PLAN:

RM200615

Friday, 29 September 2023

ROUNDABOUT TURN
AUSTROAD SINGLE UNIT TRUCK/BUS (12.5m)
RADIUS 12.5m

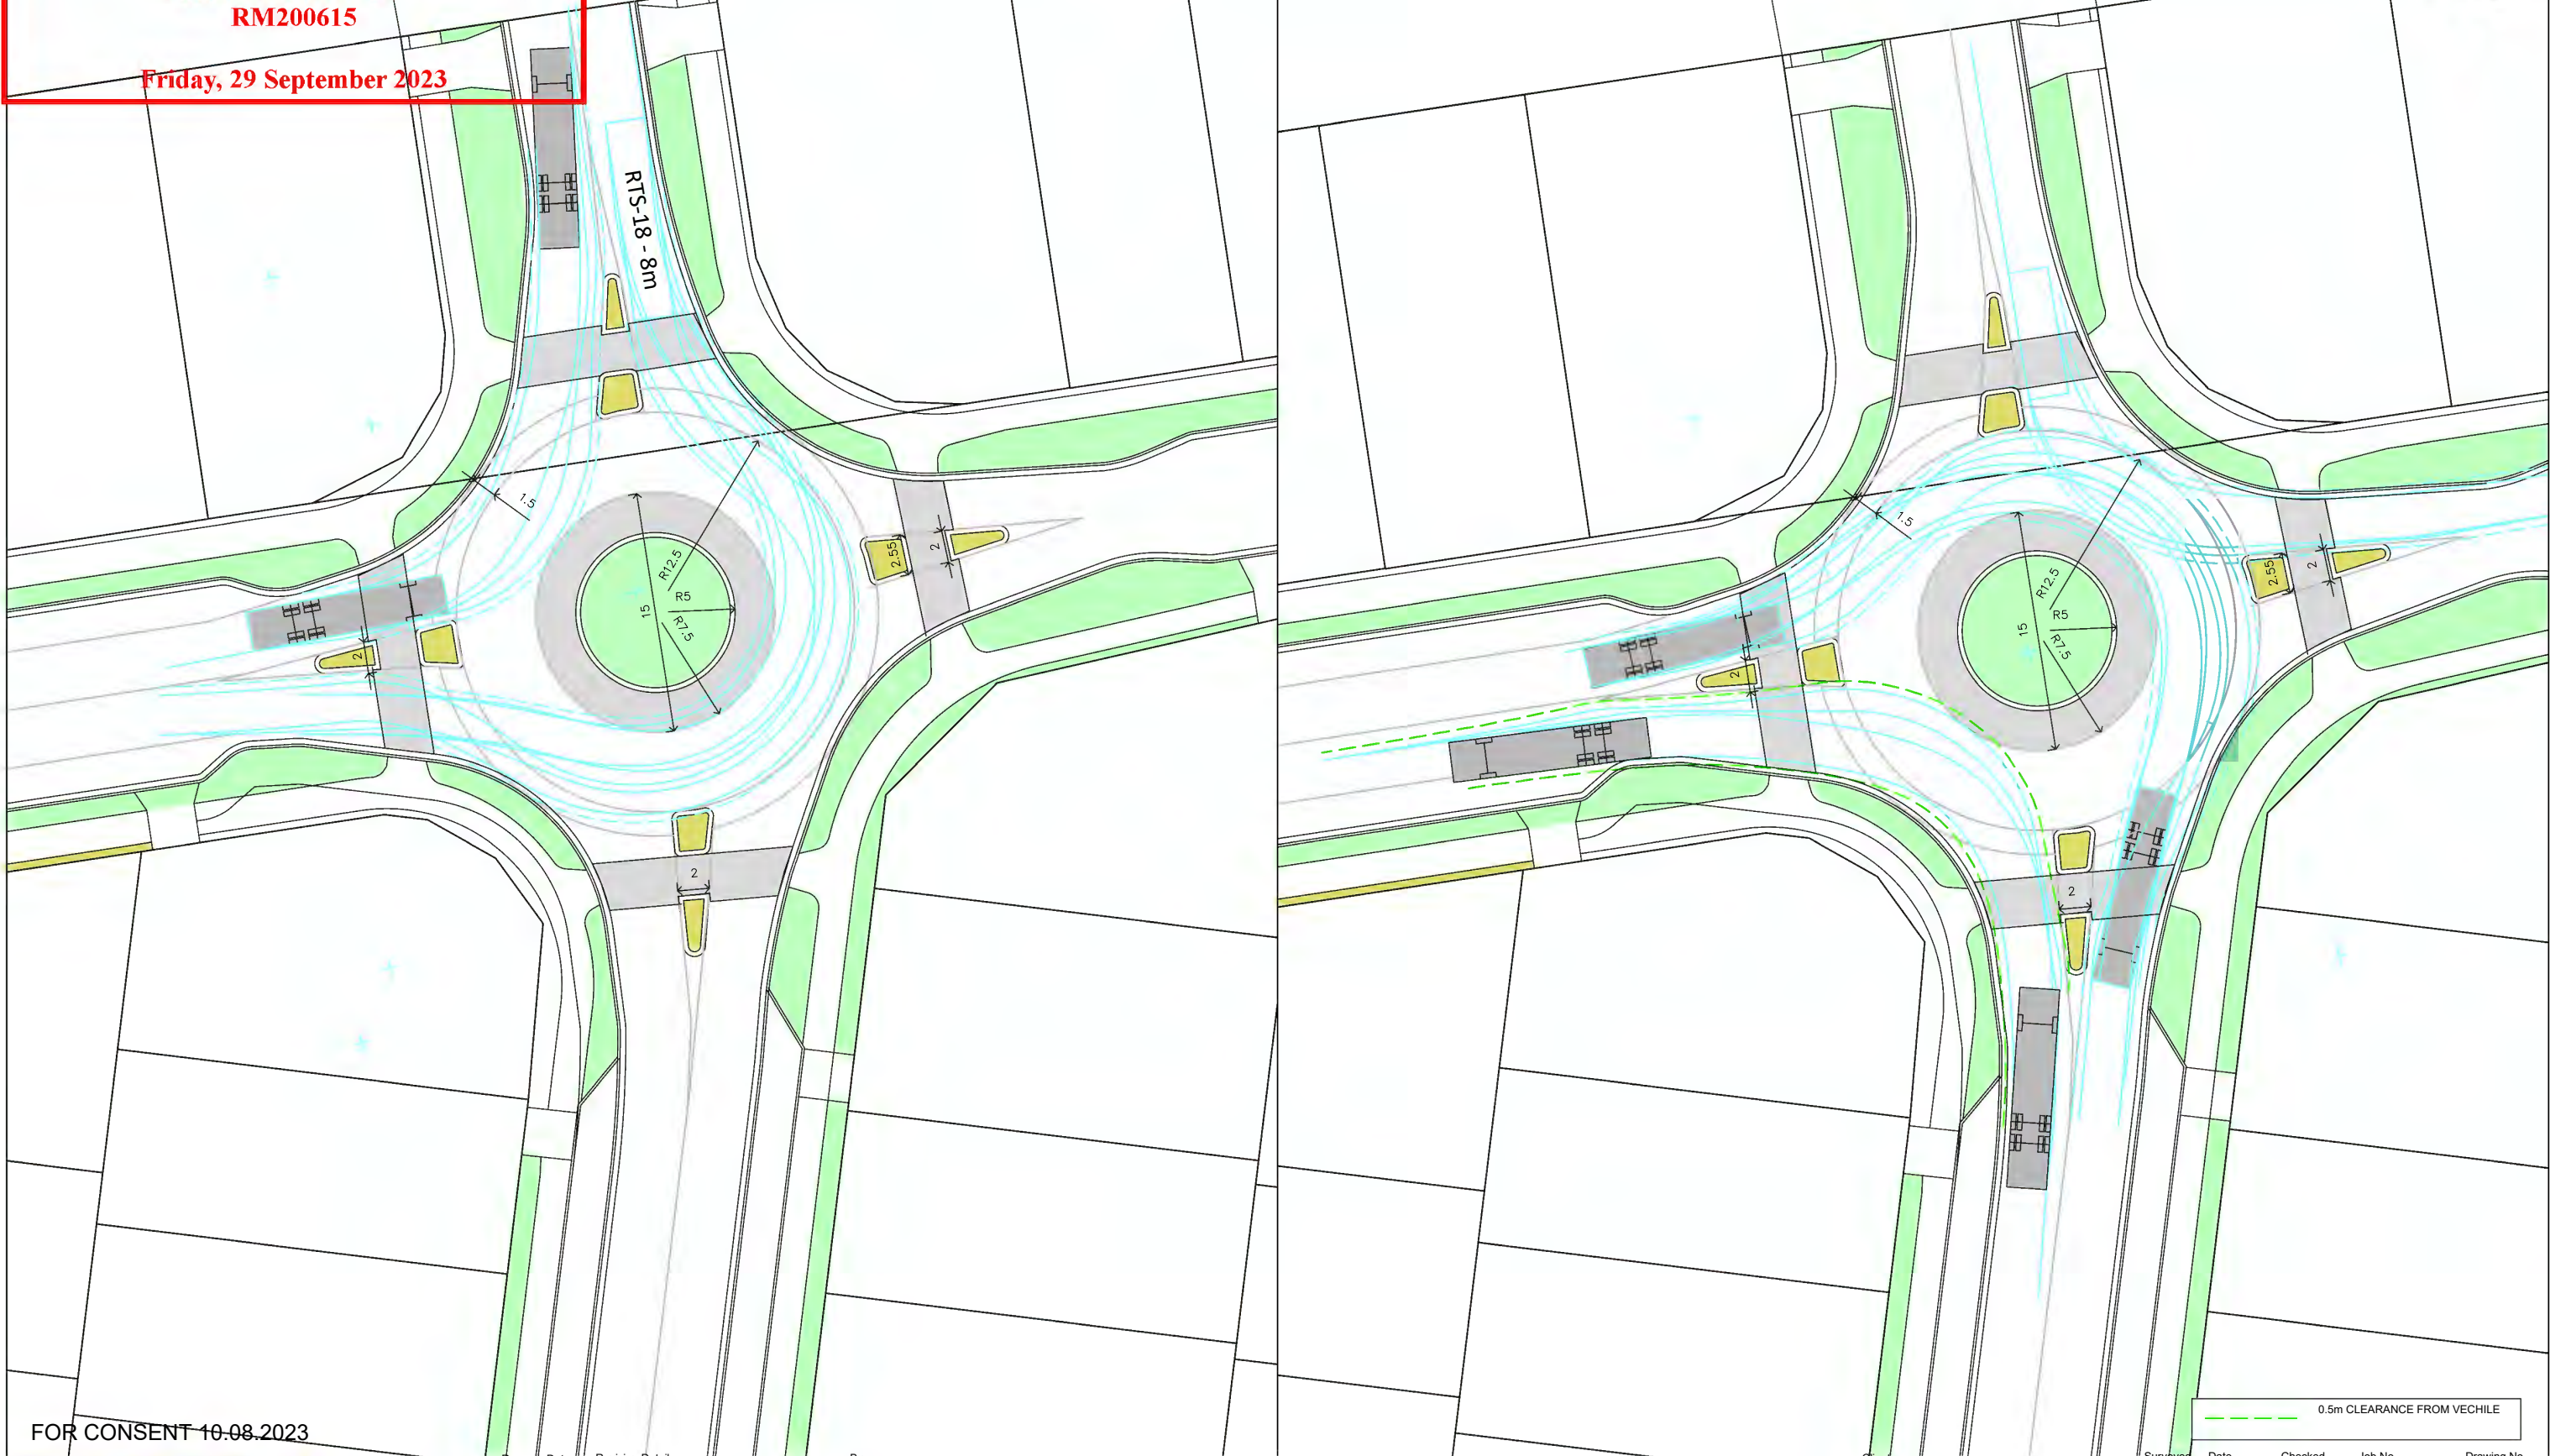

FOR CONSENT 10.08.2023

Clark Fortune McDonald & Associates
Licensed Cadastral Surveyors - Land Development - Planning Consultants
309 Lower Shotover Road, P.O. Box 553 Queenstown
Tel. (03)441-6044, Fax (03)442-1066, Email admin@cfma.co.nz
Shop 2, Otago House, 475 Moray Place, P.O. Box 5960
Tel. (03)470-1582, Fax (03)470-1583, Email admin@cfma.co.nz

Rev.	Date	Revision Details	By
D	25.05.20	Add sewer easement & update Fluent sw channel	RB
E	01.07.20	Update sewer crossing location & level	RB
F	07.07.20	Update Rising main alignment & add future stub	RB
I	17.02.21	Vehicle turning paths	JJ
J	08.03.21	Amend kerbs and intersections for turning	JJ
N	28.01.22	Add roundabout turning paths	RB
P	06.09.22	Changes following Traffic review	RB

WOOLSHED ROAD DEVELOPMENT VEHICLE TURNING PATHS AUSTROADS SINGLE UNIT TRUCK/BUS (12.5m)


HENLEY DOWNS FARM HOLDINGS LTD

Notes:
All dimensions shown are in meters unless shown otherwise.
Any person using Clark Fortune McDonald drawings and other data accepts the risk of:
- Using the drawings and other data in electronic form without requesting and checking them for accuracy against the original hard copy versions.
- Ensuring the information is the most recent issue.
- Copyright on this drawing is reserved.

Surveyed	Date	Checked	Job No.	Drawing No.
-	-	-	12983	5
Drawn	Date	Checked	Scale	Sheet 008
RB	-	-	1:400 @ A3	
Designed	Date	Checked	Datum & Level	Rev.
-	-	-	NZGD2000 / MSL	P

QUEENSTOWN LAKES DISTRICT COUNCIL
AUSTROAD SINGLE UNIT TRUCK/BUS (12.5m)
RADIUS 12.5m
APPROVED PLAN:
RM200615
Friday, 29 September 2023

LEFT TURN IN
AUSTROAD SINGLE UNIT TRUCK/BUS (12.5m)
RADIUS 12.5m

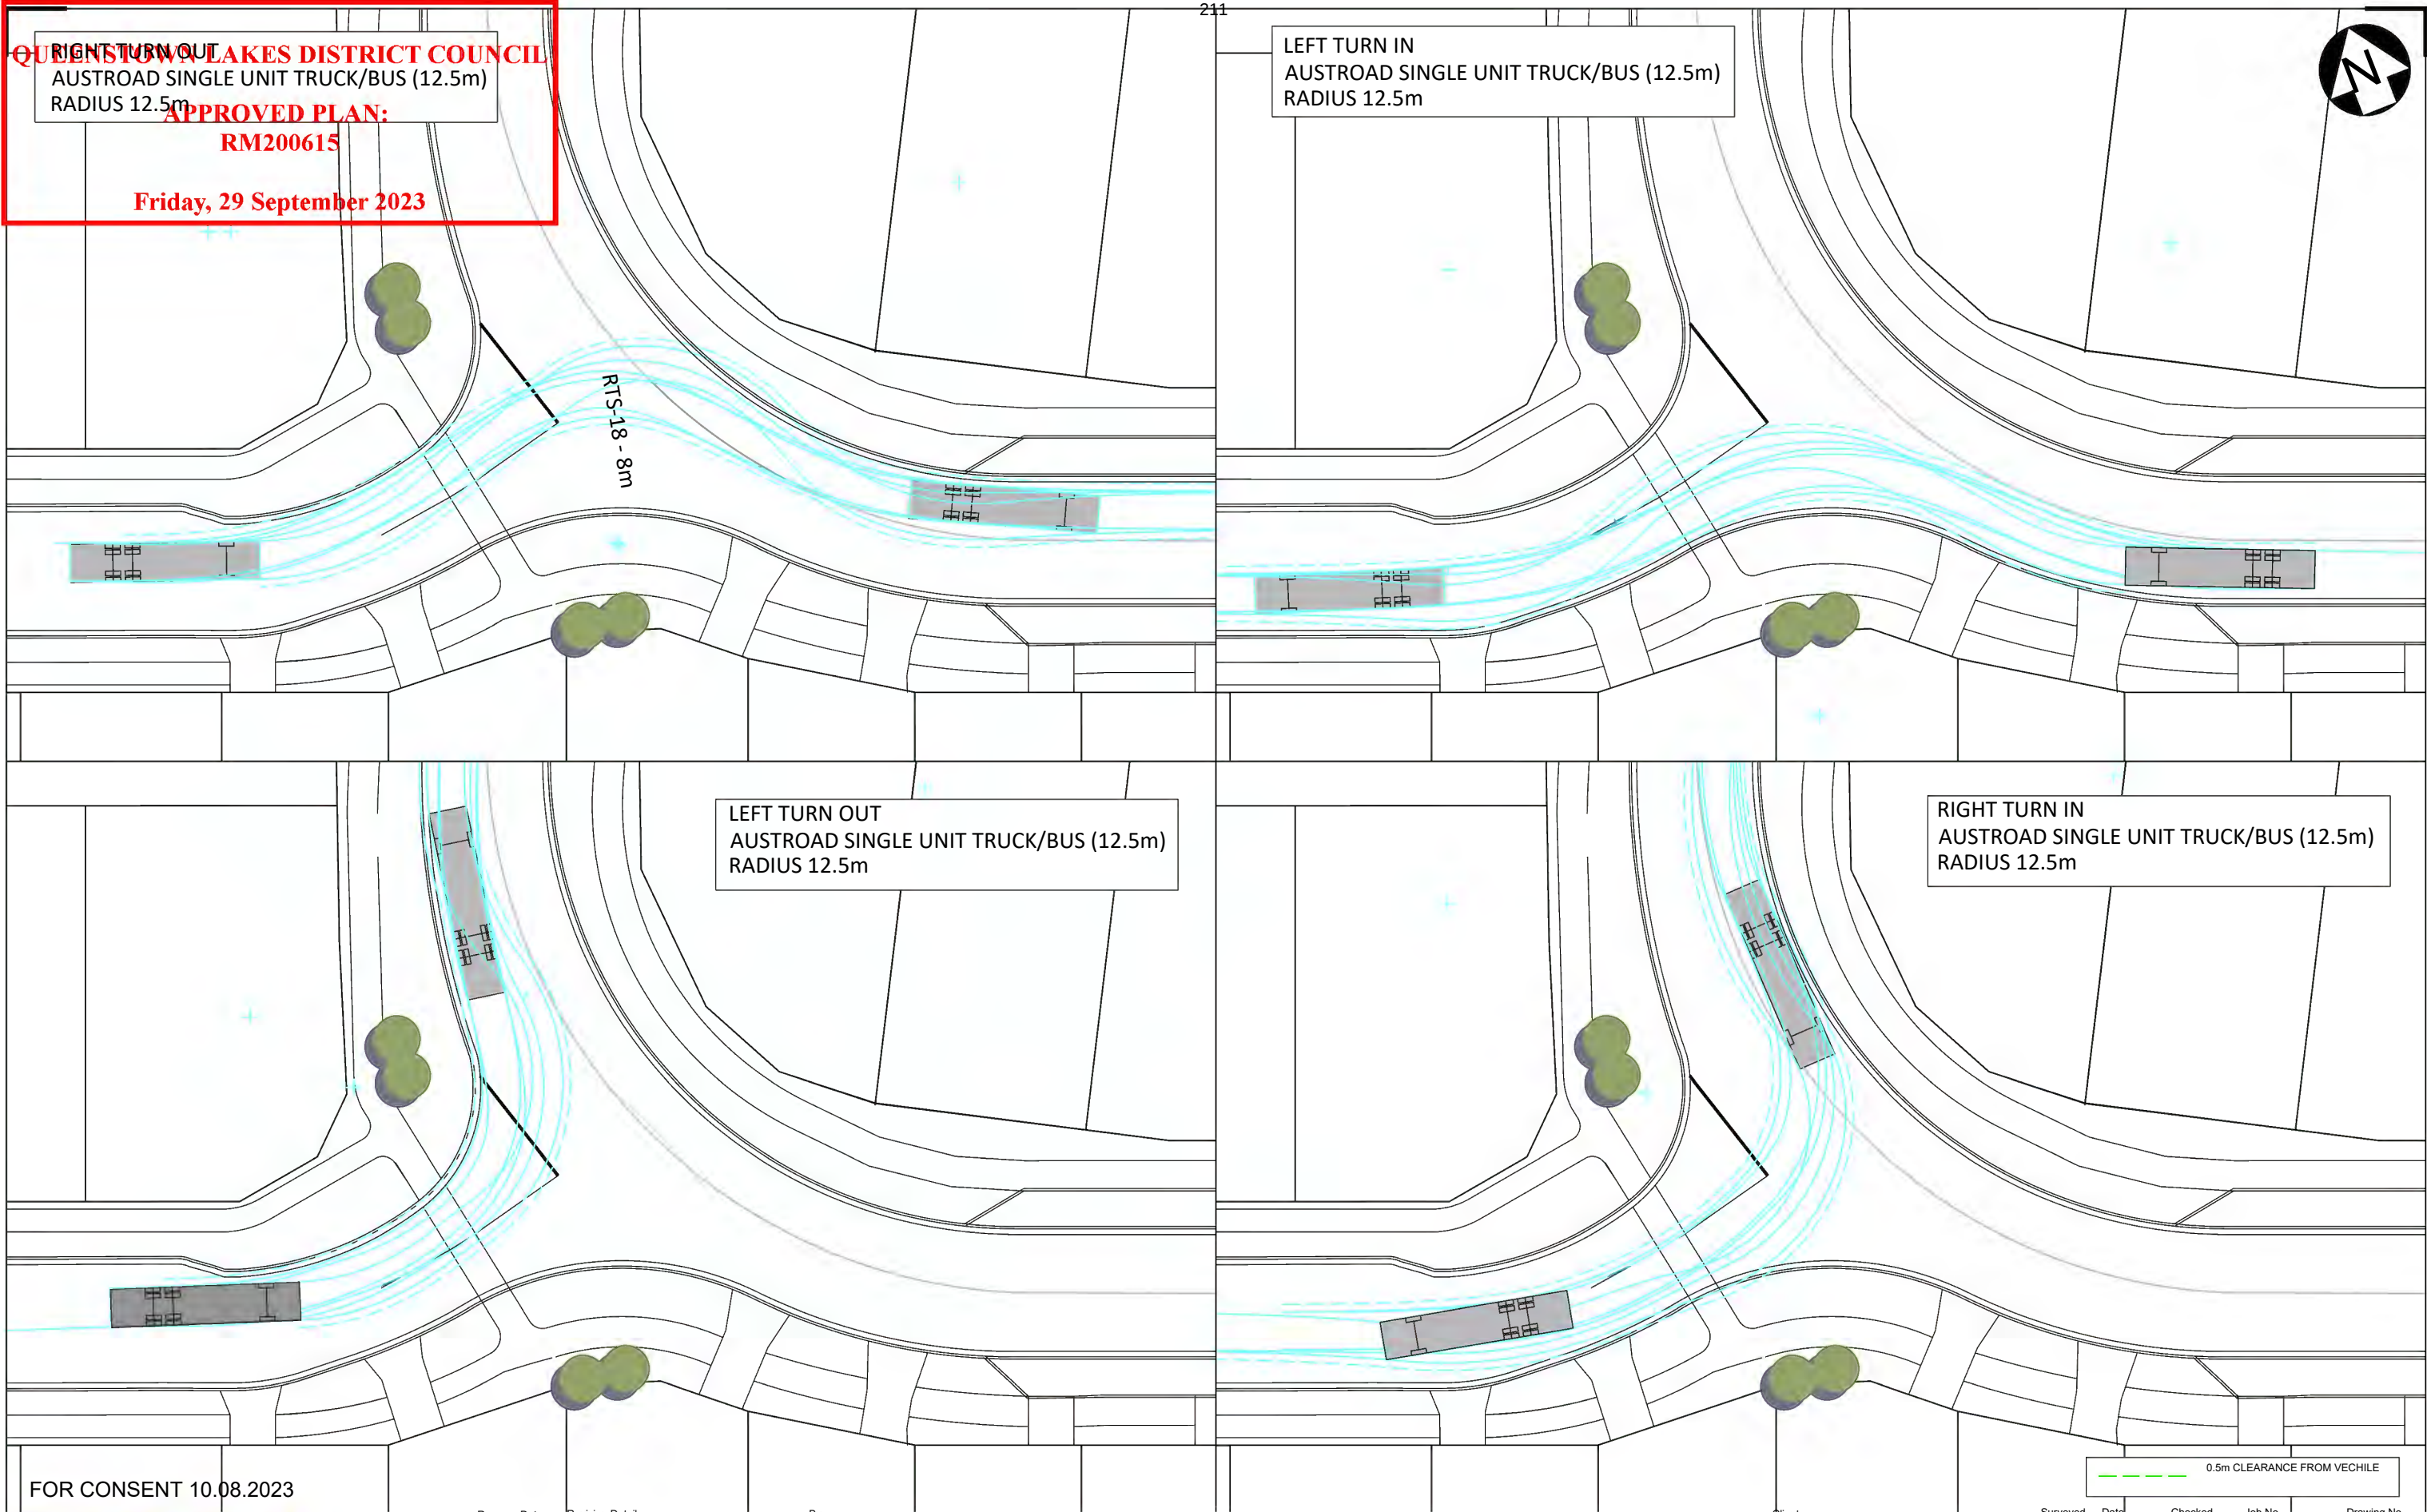

FOR CONSENT 10.08.2023

Clark Fortune McDonald & Associates
Licensed Cadastral Surveyors - Land Development - Planning Consultants
309 Lower Shotover Road, P.O. Box 553 Queenstown
Tel. (03)441-6044, Fax (03)442-1066, Email admin@cfma.co.nz
Shop 2, Otago House, 475 Moray Place, P.O. Box 5960
Tel. (03)470-1582, Fax (03)470-1583, Email admin@cfma.co.nz


Rev.	Date	Revision Details	By
D	25.05.20	Add sewer easement & update Fluent sw channel	RB
E	01.07.20	Update sewer crossing location & level	RB
F	07.07.20	Update Rising main alignment & add future stub	RB
I	17.02.21	Vehicle turning paths	JJ
J	08.03.21	Amend kerbs and intersections for turning	JJ
N	28.01.22	Add roundabout turning paths	RB
P	06.09.22	Changes following Traffic review	RB

WOOLSHED ROAD DEVELOPMENT
VEHICLE TURNING PATHS
AUSTROADS SINGLE UNIT TRUCK/BUS (12.5m)

HENLEY DOWNS FARM HOLDINGS LTD

Notes:
- All dimensions shown are in meters unless shown otherwise.
- Any person using Clark Fortune McDonald drawings and other data accepts the risk of:
- Using the drawings and other data in electronic form without requesting and checking them for accuracy against the original hard copy versions.
- Ensuring the information is the most recent issue.
- Copyright on this drawing is reserved.

Surveyed	Date	Checked	Job No.	Drawing No.
-	-	-	12983	5
Drawn	Date	Checked	Scale	Sheet 009
RB	-	-	1:400 @ A3	
Designed	Date	Checked	Datum & Level	Rev.
-	-	-	NZGD2000 / MSL	P

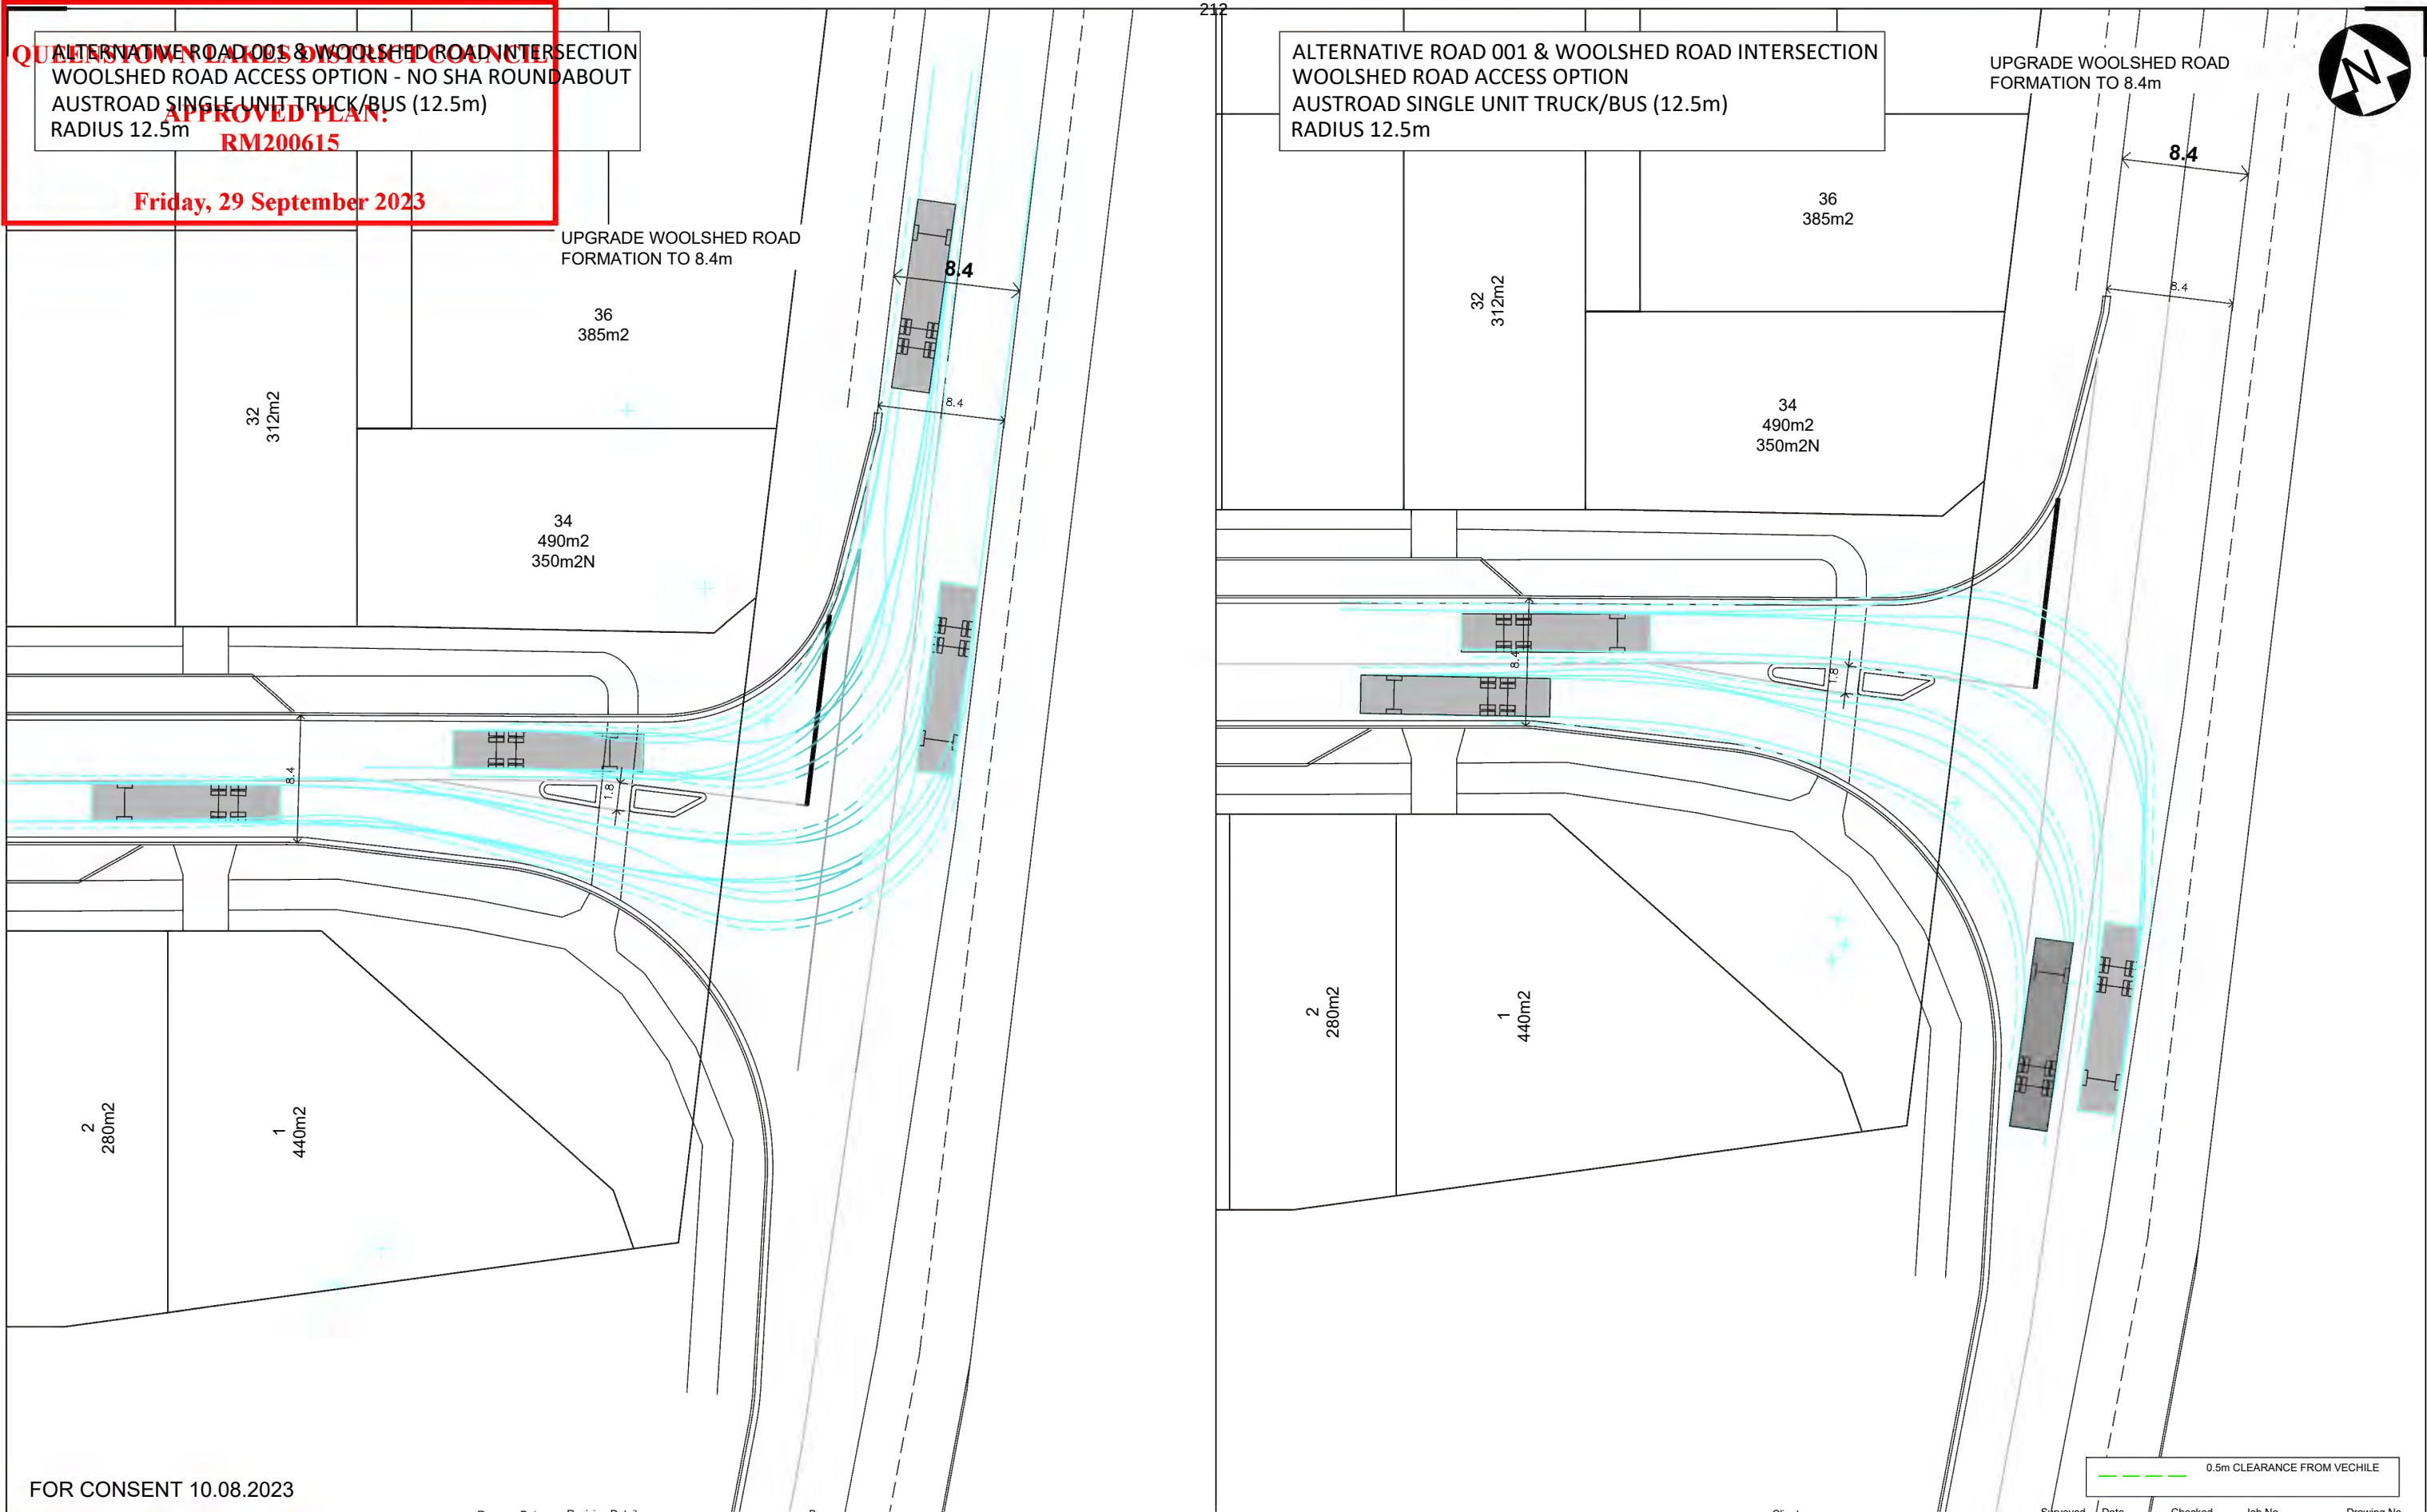

FOR CONSENT 10.08.2023



Clark Fortune McDonald & Associates
Licensed Cadastral Surveyors - Land Development - Planning Consultants
309 Lower Shotover Road, P.O. Box 553 Queenstown
Tel. (03)441-6044, Fax (03)442-1066, Email admin@cfma.co.nz

Shop 2, Otago House, 475 Moray Place, P.O. Box 5960
Tel. (03)470-1582, Fax (03)470-1583, Email admin@cfma.co.nz

Rev.	Date	Revision Details	By
C	08.05.20	Update with revised lots & reduce road 2 width	RB
D	25.05.20	Add sewer easement & update Fluent sw channel	RB
E	01.07.20	Update sewer crossing location & level	RB
F	07.07.20	Update Rising main alignment & add future stub	RB
I	17.02.21	Vehicle turning paths	JJ
J	08.03.21	Amend kerbs and intersections for turning	JJ
N	28.01.22	Add roundabout turning paths	RB

S:\JOBS\12983\acad\12983_5_PROPOSED LAYOUT_REV0.dwg Plotted: 11.08.2023

WOOLSHED ROAD DEVELOPMENT
ALTERNATIVE WOOLSHED ROAD INTERSECTION
WITH NO SHA ROUNDABOUT CONNECTION

Client		Surveyed	Date	Checked	Job No.	Drawing No.
HENLEY DOWNS FARM HOLDINGS LTD		-	-	-	12983	5
		Drawn	Date	Checked	Scale	Sheet 010
RB		-	-	-	1:400 @ A3	
Designed		Date	Checked	Datum & Level	Rev.	
		-	-	NZGD2000 / MSL	P	

Notes:
- All dimensions shown are in meters unless shown otherwise.
- Any person using Clark Fortune McDonald drawings and other data accepts the risk of:
- Using the drawings and other data in electronic form without requesting and checking them for accuracy against the original hard copy versions.
- Ensuring the information is the most recent issue.
- Copyright on this drawing is reserved.


QUEENSTOWN HARBOR DISTRICT COUNCIL

LEFT TURN ROUND BEND INTO ROAD 1
AUSTROAD SINGLE UNIT TRUCK/BUS (12.5m)
RADIUS 12.5m

APPROVED PLAN:
RM200615

Friday, 29 September 2023

RIGHT TURN OUT OF ROAD 1 INTO WOOLSHED ROAD
AUSTROAD SINGLE UNIT TRUCK/BUS (12.5m)
RADIUS 12.5m

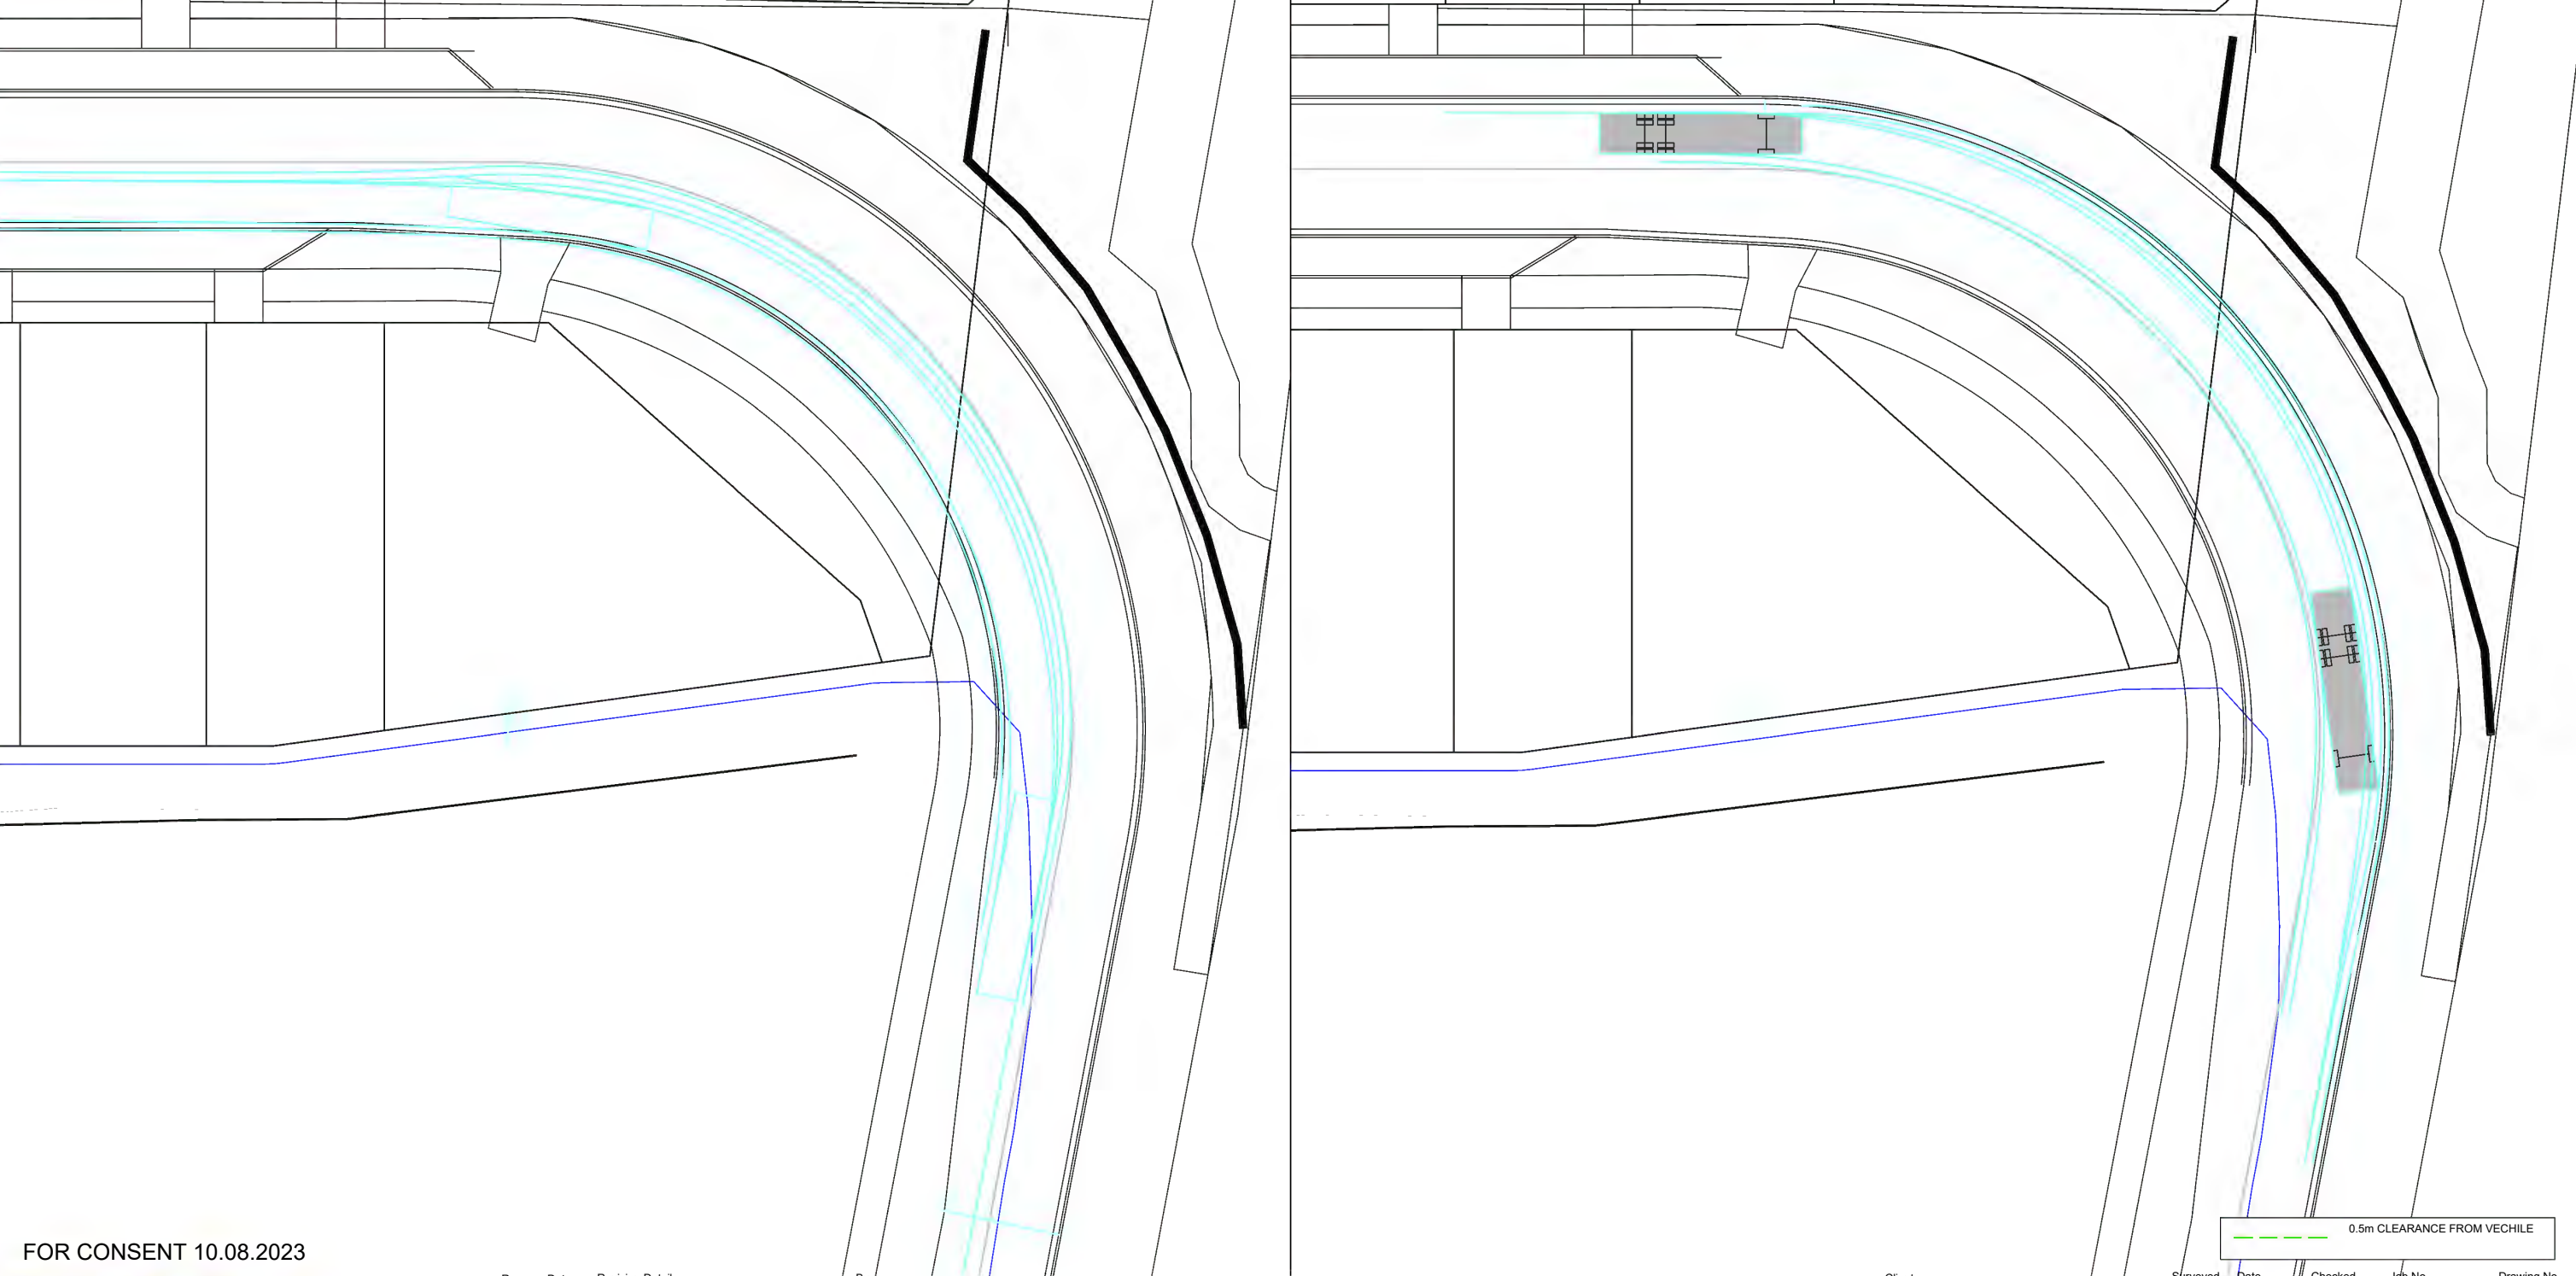

FOR CONSENT 10.08.2023

0.5m CLEARANCE FROM VEHICLE




Clark Fortune McDonald & Associates
Licensed Cadastral Surveyors - Land Development - Planning Consultants
309 Lower Shotover Road, P.O.Box 553 Queenstown
Tel. (03)441-6044, Fax (03)442-1066, Email admin@cfma.co.nz

Shop 2, Otago House, 475 Moray Place, P.O. Box 5960
Tel. (03)470-1582, Fax (03)470-1583, Email admin@cfma.co.nz

Rev.	Date	Revision Details	By
D	25.05.20	Add sewer easement & update Fluent sw channel	RB
E	01.07.20	Update sewer crossing location & level	RB
F	07.07.20	Update Rising main alignment & add future stub	RB
I	17.02.21	Vehicle turning paths	JJ
J	08.03.21	Amend kerbs and intersections for turning	JJ
N	28.01.22	Add roundabout turning paths	RB
P	3.10.22	Amend as per council engineer request	RB

WOOLSHED ROAD DEVELOPMENT
WOOLSHED ROAD INTO ROAD 1 BEND

Client	Surveyed	Date	Checked	Job No.	Drawing No.
HENLEY DOWNS FARM HOLDINGS LTD	-	-	-	12983	5
					Sheet 011
Notes: All dimensions shown are in meters unless shown otherwise. Any person using Clark Fortune McDonald drawings and other data accepts the risk of: - Using the drawings and other data in electronic form without requesting and checking them for accuracy against the original hard copy versions. - Ensuring the information is the most recent issue. - Copyright on this drawing is reserved.	Drawn	Date	Checked	Scale	
	RB	-	-	1:400 @ A3	
	Designed	Date	Checked	Datum & Level	Rev.
	-	-	-	NZGD2000 / MSL	P

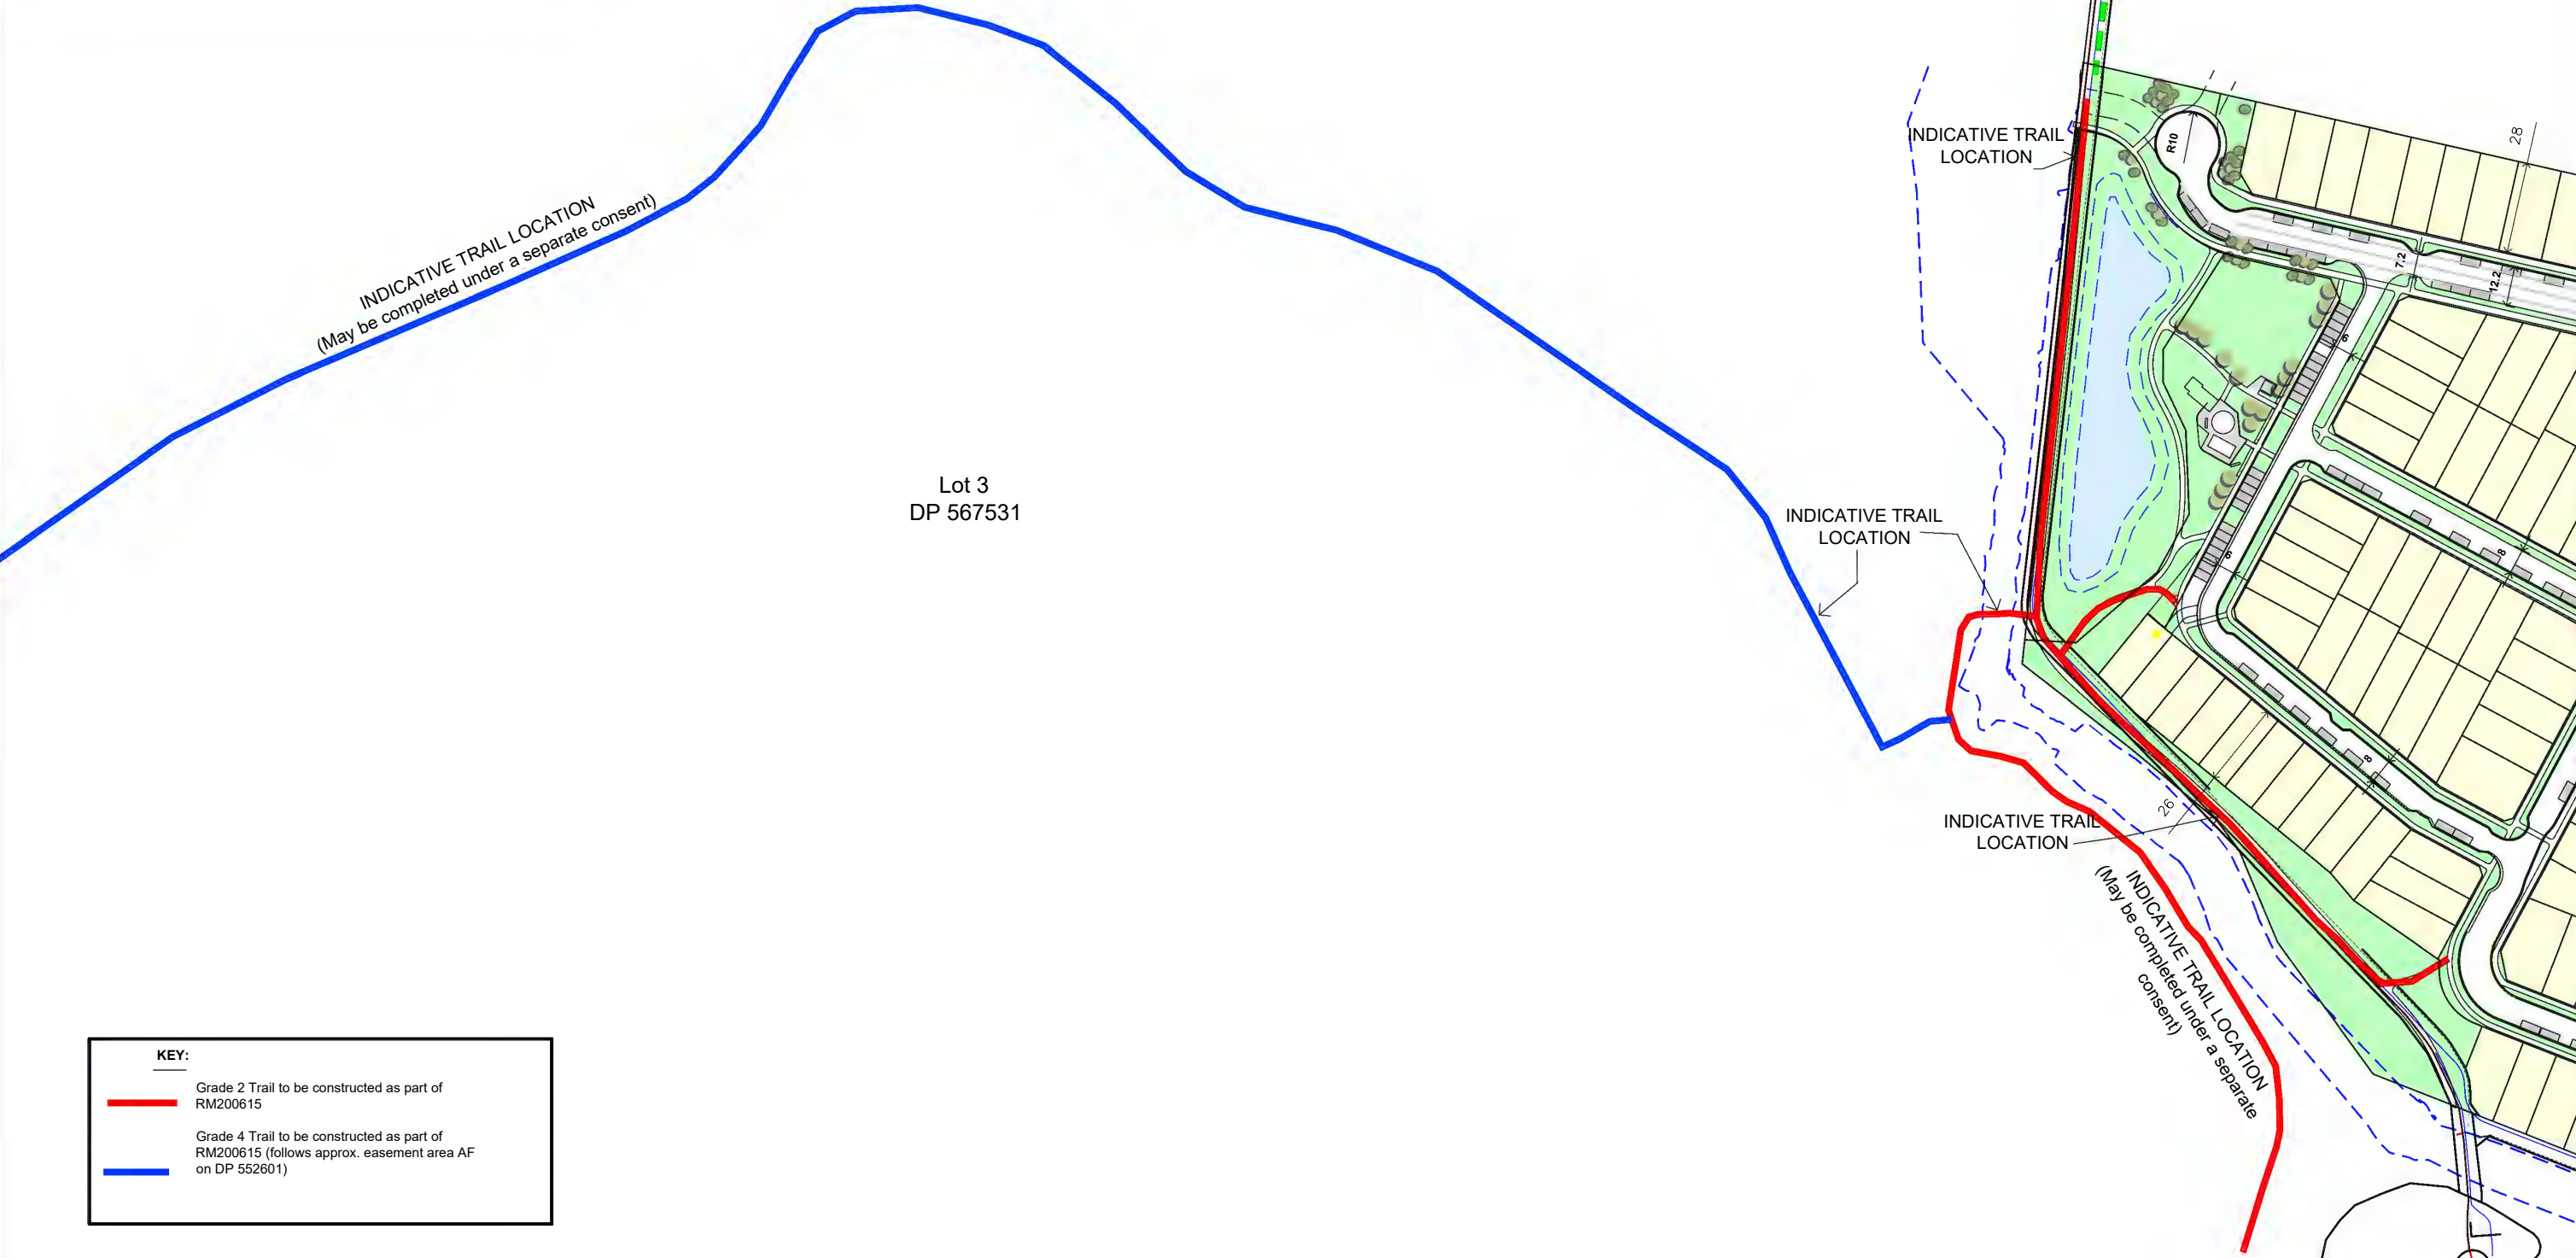

KEY:

Grade 2 Trail to be constructed as part of RM200615

Grade 4 Trail to be constructed as part of RM200615 (follows approx. easement area AF on DP 552601)

FOR CONSENT 10.08.2023



Clark Fortune McDonald & Associates

Licensed Cadastral Surveyors - Land Development - Planning Consultants

309 Lower Shotover Road, P.O.Box 553 Queenstown
Tel. (03)441-6044, Fax (03)442-1066, Email admin@cfma.co.nz

Shop 2, Otago House, 475 Moray Place, P.O. Box 5960
Tel. (03)470-1582, Fax (03)470-1583, Email admin@cfma.co.nz

Rev.	Date	Revision Details	By
A	2.03.22	Add in grades to trails	ED
B	10.08.23	Add notes to Plan	ED

WOOLSHED ROAD DEVELOPMENT
TRAILS PLAN

Client	Surveyed	Date	Checked	Job No.	Drawing No.
HENLEY DOWNS FARM HOLDINGS LTD	-	-	-	12983	5
					Sheet 012
					Scale 1:1000.000 @ A1
					0.500000 @ A3
					Datum & Level
					NZGD2000 / MSL
					Rev. B

QUEENSTOWN LAKES DISTRICT COUNCIL

APPROVED PLAN:

RM200615

FUTURE CONNECTION

Friday, 29 September 2023

215

OSL

OSL

OSL

OSA

R(HD-SH)-3

OSA

R(HD)-D

FOR CLIENT REVIEW 01.07.2020



Clark Fortune McDonald & Associates

Licensed Cadastral Surveyors - Land Development - Planning Consultants
309 Lower Shotover Road, P.O.Box 553 Queenstown
Tel. (03)441-6044, Fax (03)442-1066, Email admin@cfma.co.nz

Shop 2, Otago House, 475 Moray Place, P.O. Box 5960
Tel. (03)470-1582, Fax (03)470-1583, Email admin@cfma.co.nz

Rev.	Date	Revision Details	By
A	20.07.2020	Amend consent notice boundary on lots 270-272	ED
B	17.11.2020	Amend reserve-lot 302 and add dimensions	ED
C	12.07.21	Lot sizes changes	NT
D	19.01.22	Add annotations for activity areas etc for council	ED
E	11.04.22	Add access to the north onto plan	ED
F	29.09.22	Amend plan to reflect new layout	ED

WOOLSHED ROAD DEVELOPMENT SUBDIVISION SCHEME PLAN

HENLEY DOWNS FARM HOLDINGS LTD


Notes:
All dimensions shown are in meters unless shown otherwise.
Any person using Clark Fortune McDonald drawings and other data accepts the risk of:
- Using the drawings and other data in electronic form without requesting and checking them for accuracy against the original hard copy versions.
- Ensuring the information is the most recent issue.
- Copyright on this drawing is reserved.

Surveyed	Date	Checked	Job No	Drawing No
-	-	-	12983	8
Drawn	Date	Checked	Scale	Sheet 001
NT	01.07.20	-	1:1000 @ A1 1:2000 @ A3	
Designed	Date	Checked	Datum & Level	Rev
-	-	-	NZGD2000 / MSL	F

QUEENSTOWN LAKES DISTRICT COUNCIL

APPROVED PLAN:
RM200615

Friday, 29 September 2023

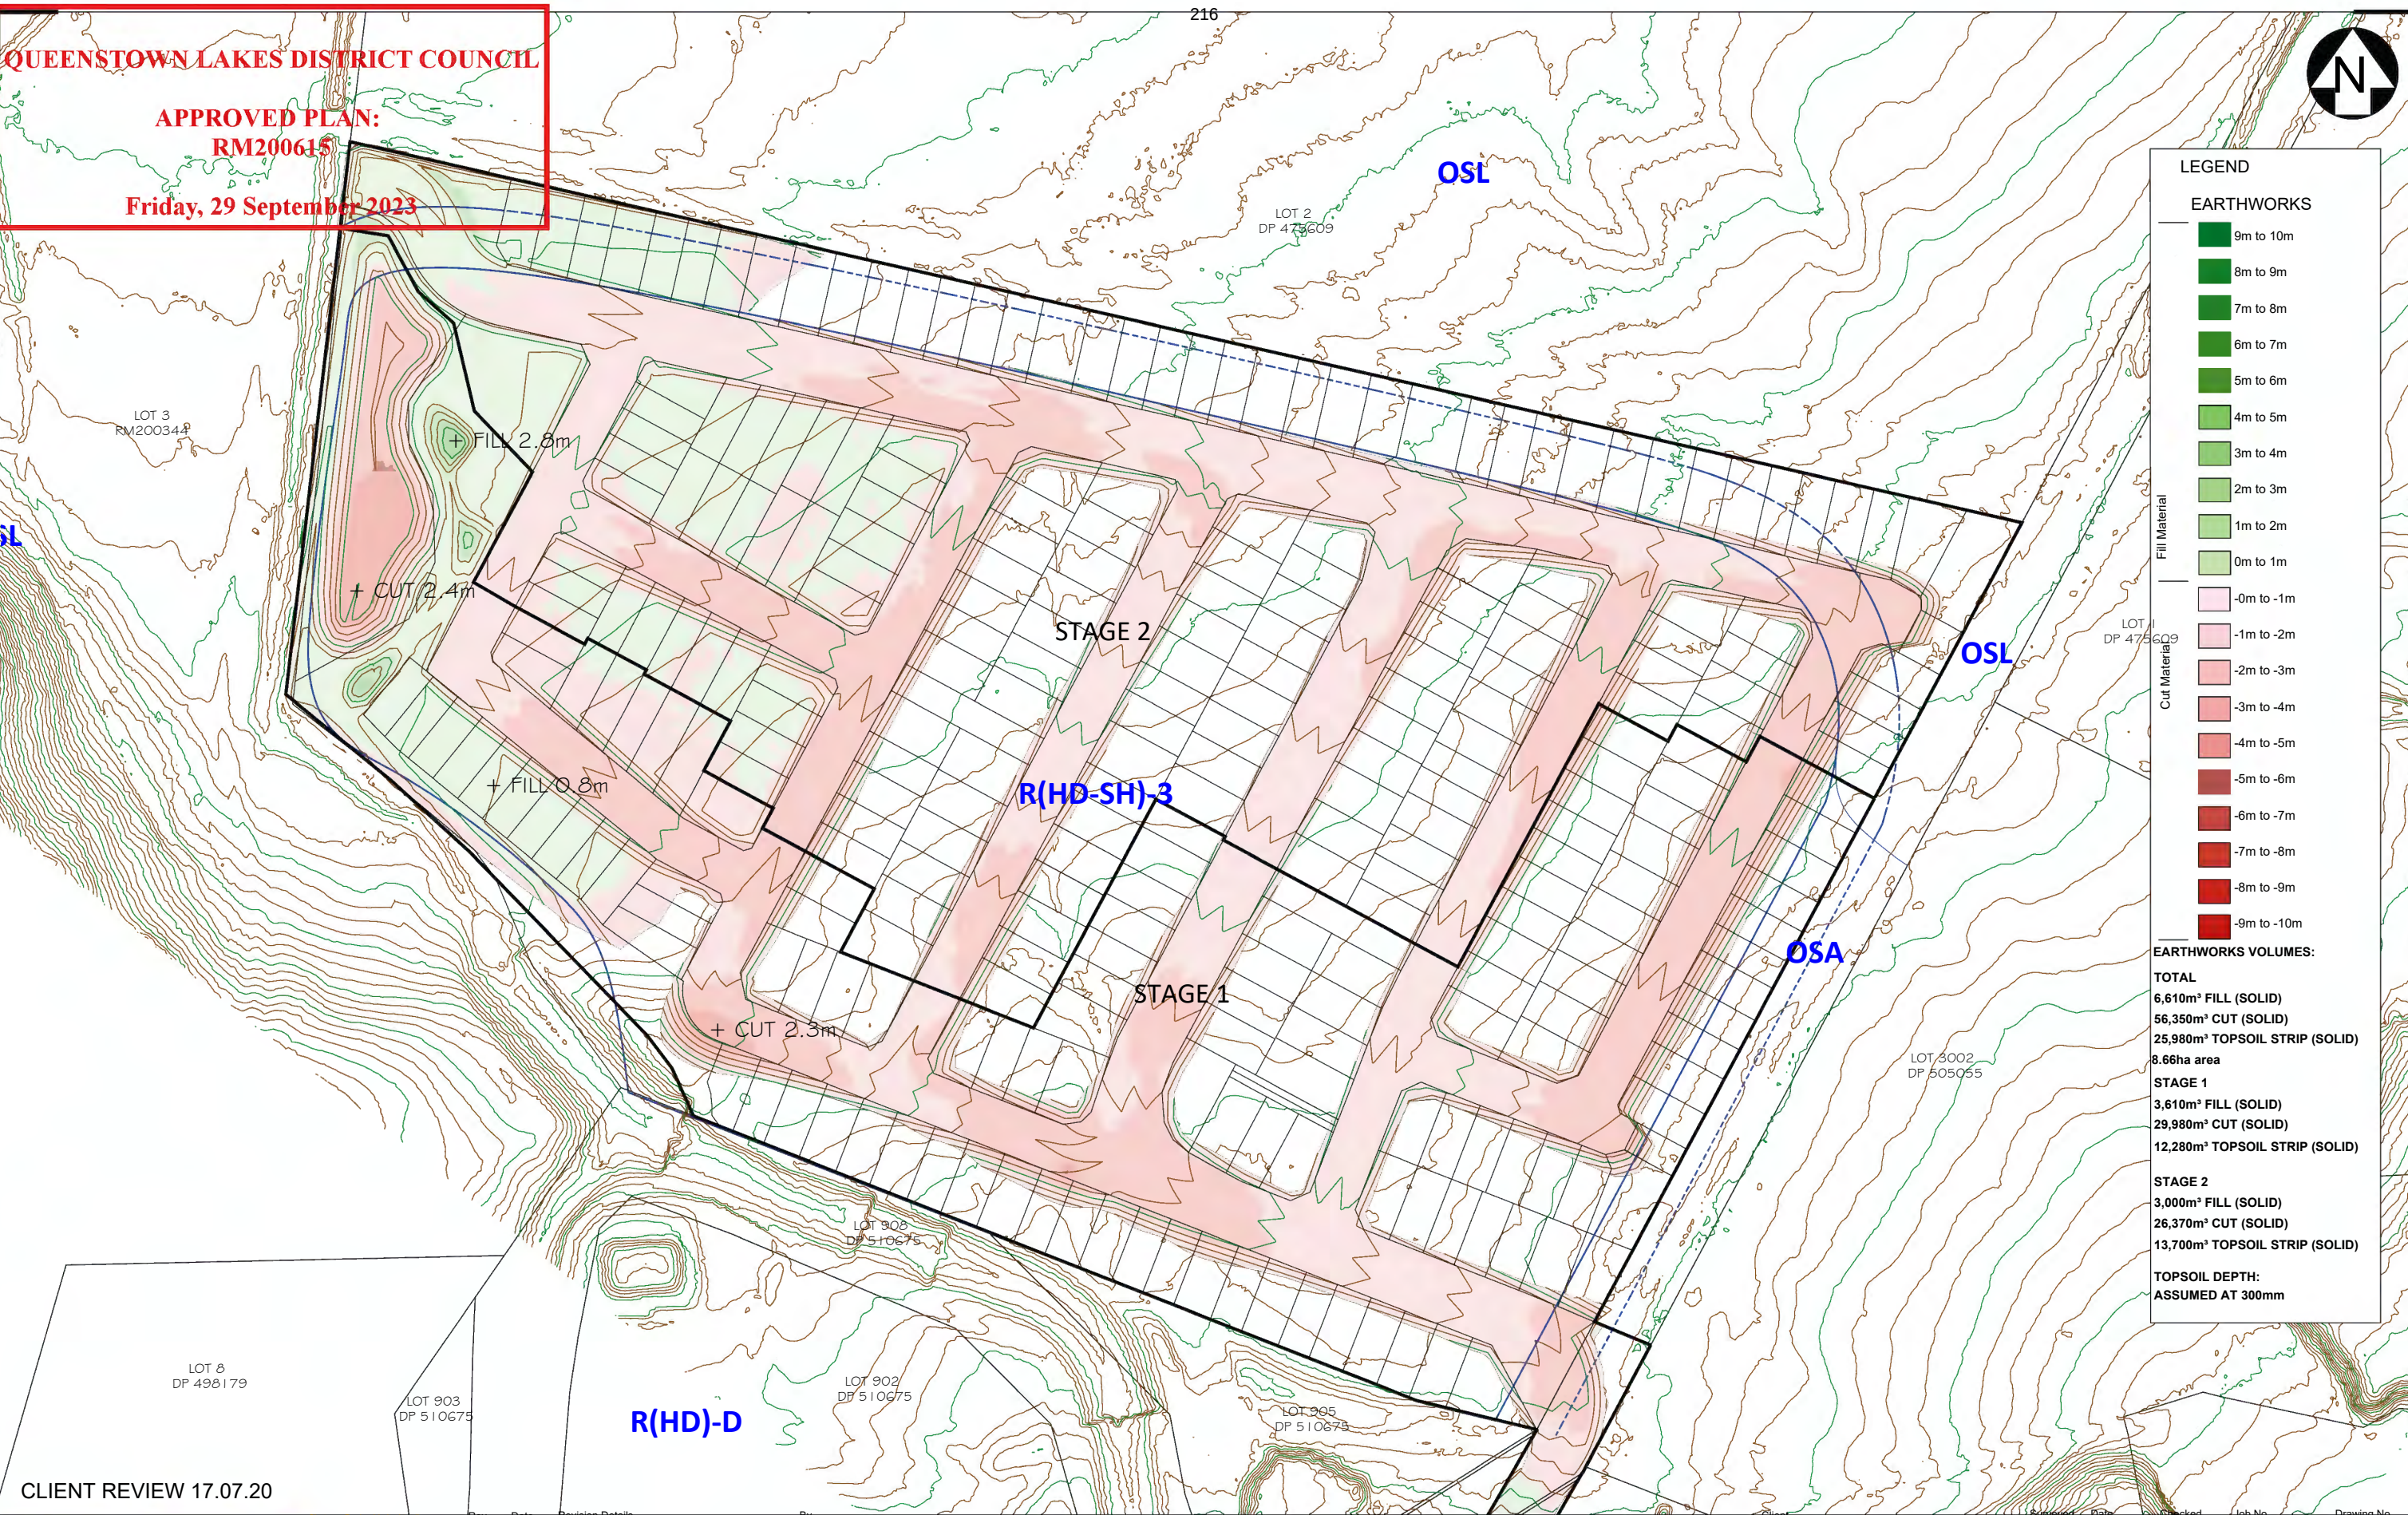

LEGEND

EARTHWORKS

Fill Material

- 9m to 10m
- 8m to 9m
- 7m to 8m
- 6m to 7m
- 5m to 6m
- 4m to 5m
- 3m to 4m
- 2m to 3m
- 1m to 2m
- 0m to 1m

Cut Material

- 0m to -1m
- 1m to -2m
- 2m to -3m
- 3m to -4m
- 4m to -5m
- 5m to -6m
- 6m to -7m
- 7m to -8m
- 8m to -9m
- 9m to -10m

EARTHWORKS VOLUMES:

TOTAL

- 6,610m³ FILL (SOLID)
- 56,350m³ CUT (SOLID)
- 25,980m³ TOPSOIL STRIP (SOLID)
- 8.66ha area

STAGE 1

- 3,610m³ FILL (SOLID)
- 29,980m³ CUT (SOLID)
- 12,280m³ TOPSOIL STRIP (SOLID)

STAGE 2

- 3,000m³ FILL (SOLID)
- 26,370m³ CUT (SOLID)
- 13,700m³ TOPSOIL STRIP (SOLID)

TOPSOIL DEPTH:

ASSUMED AT 300mm

CLIENT REVIEW 17.07.20

Clark Fortune McDonald & Associates
Licensed Cadastral Surveyors - Land Development - Planning Consultants

309 Lower Shotover Road, P.O.Box 553 Queenstown
Tel. (03)441-6044, Fax (03)442-1066, Email admin@cfma.co.nz

Shop 2, Otago House, 475 Moray Place, P.O. Box 5960
Tel. (03)470-1582, Fax (03)470-1583, Email admin@cfma.co.nz

Rev.	Date	Revision Details	By
A	11.08.21	STAGING VOLUMES ADDED	NT
B	10.08.22	AMEND ALIGNMENTS, BDYS, STAGE BDY	JJ

**WOOLSHED ROAD DEVELOPMENT
PROPOSED EARTHWORKS**

HENLEY DOWNS FARM HOLDINGS LTD

Notes:
All dimensions shown are in meters unless shown otherwise.
Any person using Clark Fortune McDonald drawings and other data accepts the risk of:
- Using the drawings and other data in electronic form without requesting and checking them for accuracy against the original hard copy versions.
- Ensuring the information is the most recent issue.
- Copyright on this drawing is reserved.

Drawn: RB, Date: 17.07.20, Checked: -


Designed: -, Date: -, Checked: -

Scale: 1:1000 @ A1, 1:2000 @ A3

Datum & Level: NZGD2000 / MSL, Rev: B

Sheet 001

APPROVED PLAN:
RM200615

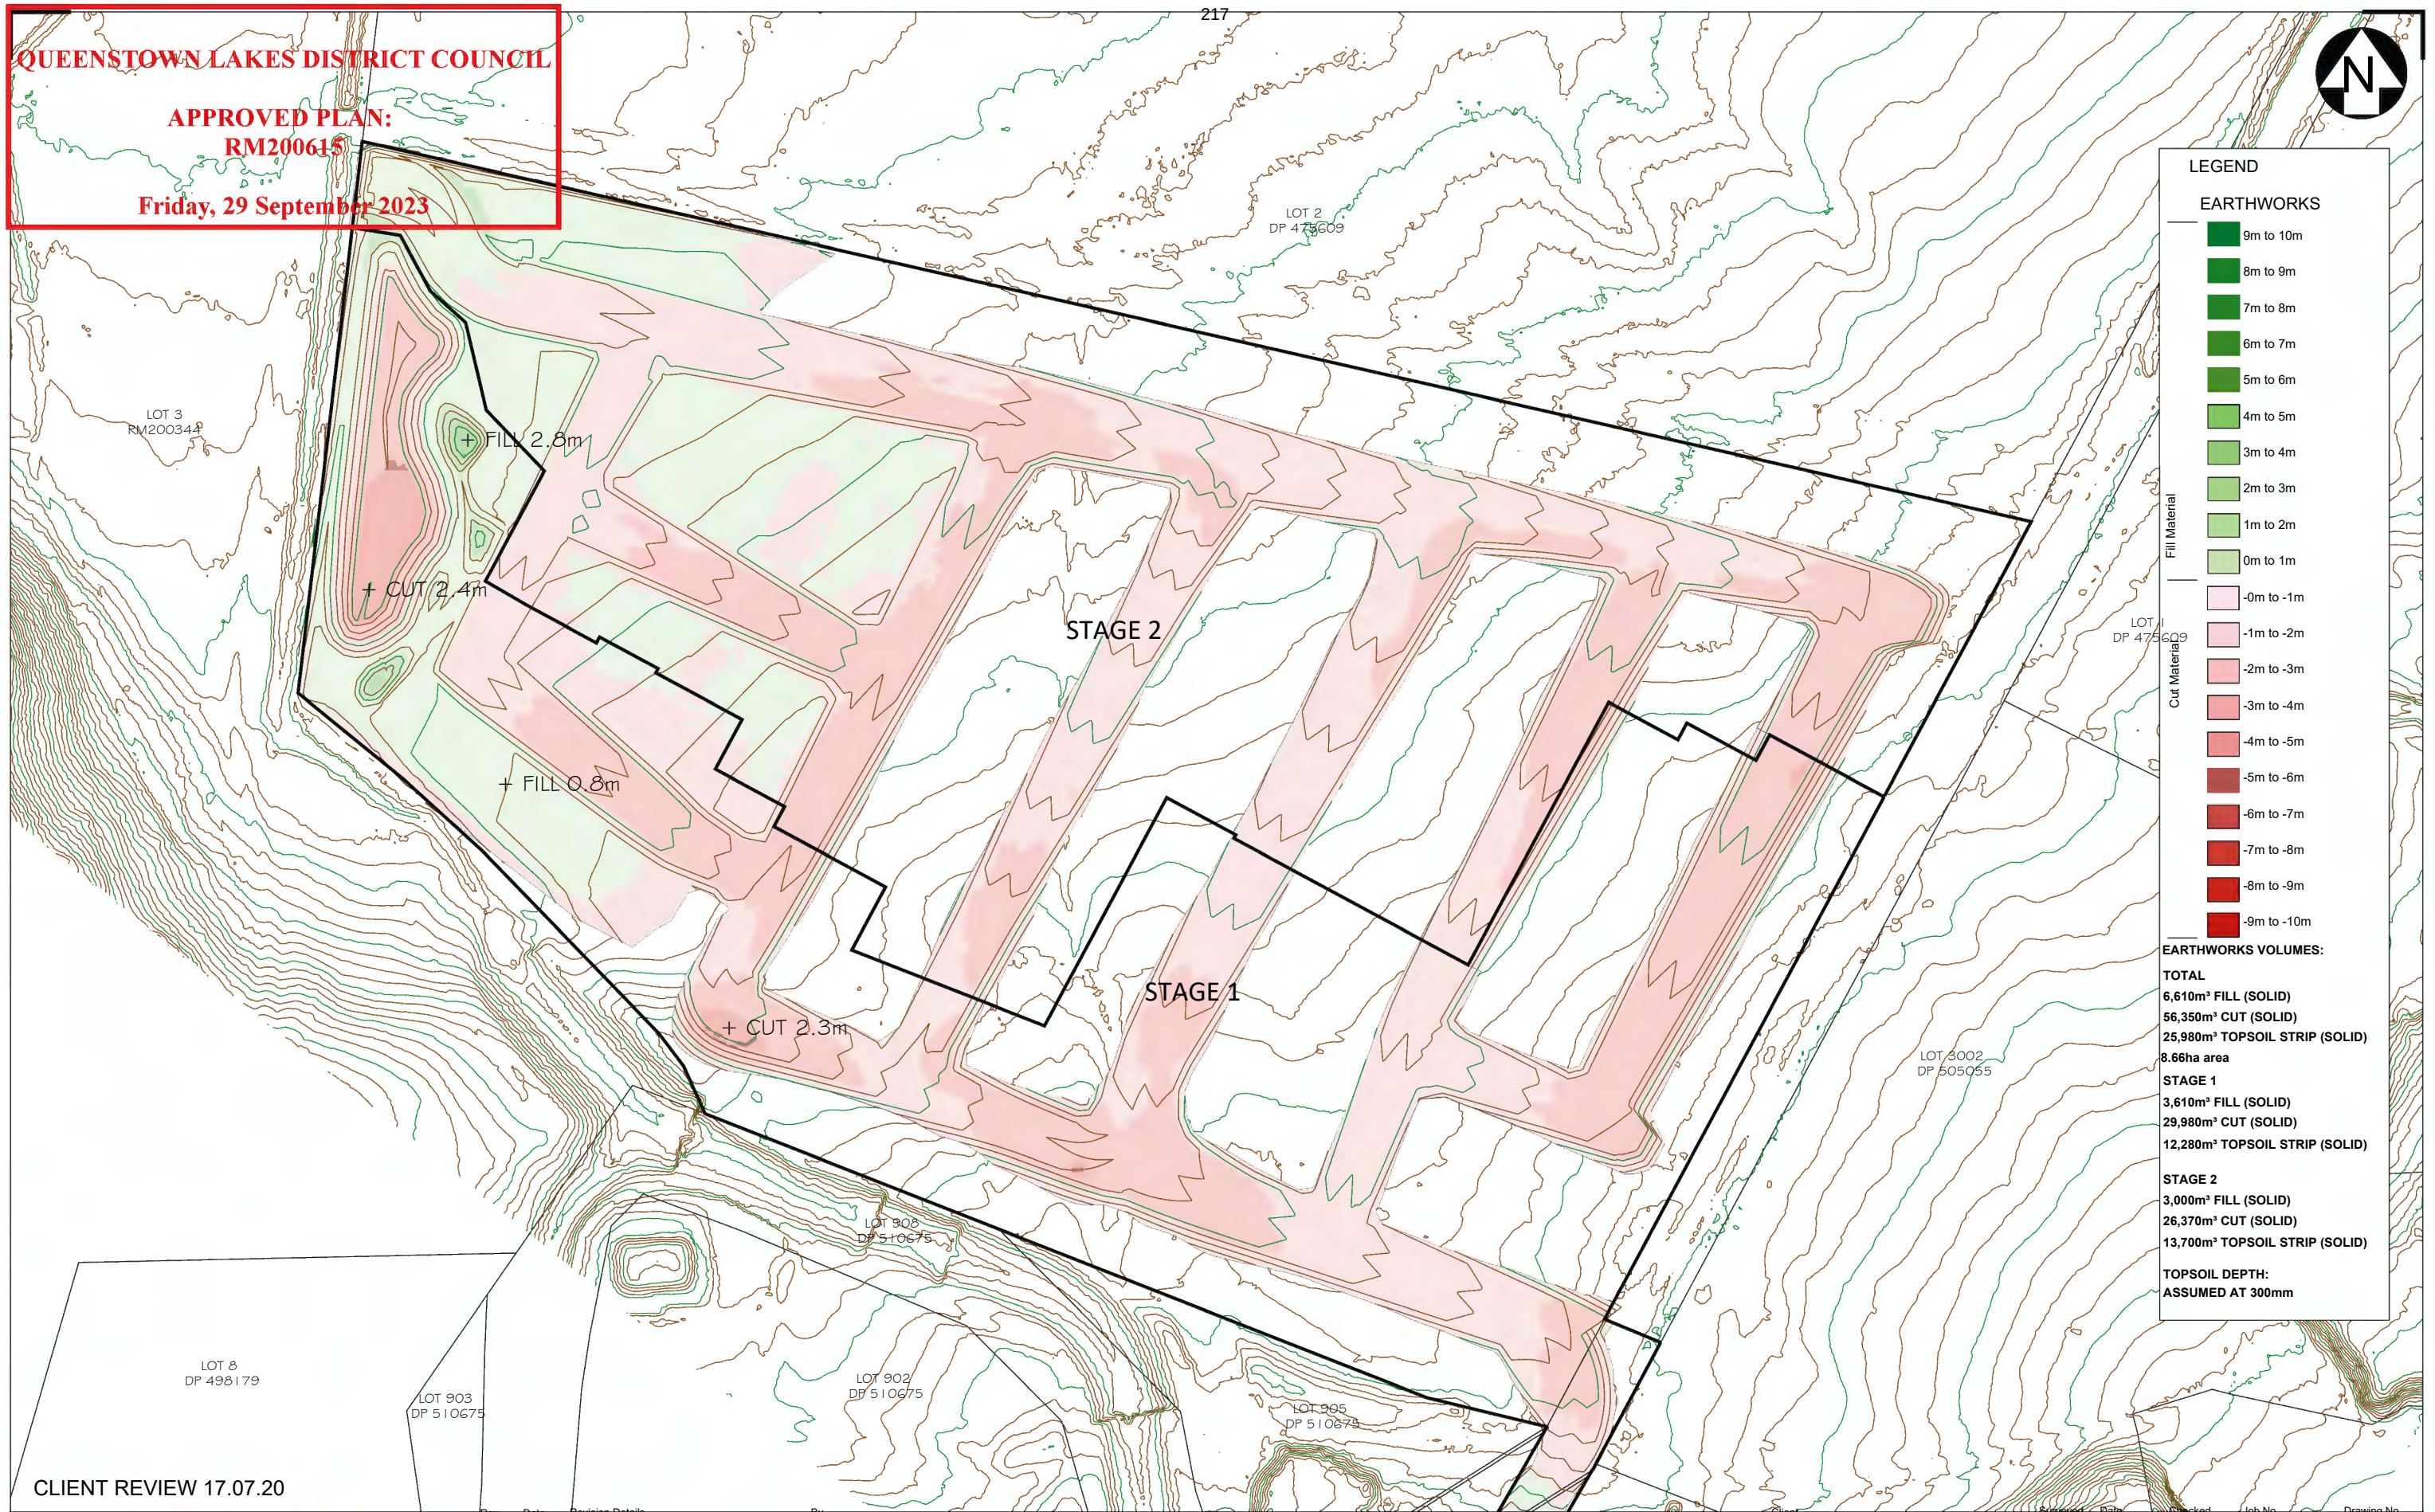

 **Clark Fortune McDonald & Associates**
Licensed Cadastral Surveyors - Land Development - Planning Consultants

309 Lower Shotover Road, P.O.Box 553 Queenstown
Tel. (03)441-6044, Fax (03)442-1066, Email admin@cfma.co.nz

Shop 2, Otago House, 475 Moray Place, P.O. Box 5960
Tel. (03)470-1582, Fax (03)470-1583, Email admin@cfma.co.nz

S:\JOBS\12900\12983\acad\12983_9_Earthworks_REV B.dwg Plotted: 10.08.2012


Clark Fortune McDonald & Associates
 Licensed Cadastral Surveyors - Land Development - Planning Consultants
 309 Lower Shotover Road, P.O.Box 553 Queenstown
 Tel. (03)441-6044, Fax (03)442-1066, Email admin@cfma.co.nz
 Shop 2, Otago House, 475 Moray Place, P.O. Box 5960
 Tel. (03)470-1582, Fax (03)470-1583, Email admin@cfma.co.nz
 S:\JOBS\12900\12983\acad\12983_9_Earthworks_REV B.dwg Plotted: 10/08/2022

WOOLSHED ROAD DEVELOPMENT PROPOSED EARTHWORKS

HENLEY DOWNS FARM HOLDINGS LTD

Notes:

- All dimensions shown are in meters unless shown otherwise.
- Any person using Clark Fortune McDonald drawings and other data accepts the risk of:
 - Using the drawings and other data in electronic form without requesting and checking them for accuracy against the original hard copy versions.
 - Ensuring the information is the most recent issue.
 - Copyright on this drawing is reserved.

	-	-	-	09
Drawn	Date	Checked	Scale	Sheet 002
RB	17.07.20	-	1:1000 @ A1 1:2000 @ A3	
Designed	Date	Checked	Datum & Level	Rev.
		-	NZGD2000 / MSL	B

QUEENSTOWN LAKES DISTRICT COUNCIL

APPROVED PLAN:

RM200615

Friday, 29 September 2023

218

Stage	Lots	Start	Completion
1	27	Feb 23	August 23
2	43	August 23	Feb 24
3	55	Feb 24	Sept 24
4	67	August 24	March 25
5	44	Feb 25	Sept 25
6	35	Sept 25	Jan 26

FOR CLIENT REVIEW 01.07.2020

 **Clark Fortune McDonald & Associates**
Licensed Cadastral Surveyors - Land Development - Planning Consultants
309 Lower Shotover Road, P.O.Box 553 Queenstown
Tel. (03)441-6044, Fax (03)442-1066, Email admin@cfma.co.nz

Shop 2, Otago House, 475 Moray Place, P.O. Box 5960
Tel. (03)470-1582, Fax (03)470-1583, Email admin@cfma.co.nz

C:\Emmas\12983_17_Staging Plan_Rev A.dwg Plotted: 30.09.2022

Rev.	Date	Revision Details	By
A	Sep 22	Amend stages 1, 5 and 6	ED

WOOLSHED ROAD DEVELOPMENT STAGING PLAN

Client	Surveyed	Date	Checked	Job No	Drawing No
HENLEY DOWNS FARM HOLDINGS LTD	-	-	-	12983	17
Drawn	Date	Checked	Scale	1:1000 @ A1	Sheet 001
NT	01.07.20	-	1:2000 @ A3		
Designed	Date	Checked	Datum & Level	Rev	
-	-	-	NZGD2000 / MSL	A	



MASTERPLAN		PUBLISHED	REV
LAYOUT			
SK01	LOCATION PLAN	☐	D
SK02	SITE ANALYSIS PLAN	☐	C
SK03	OVERALL MASTERPLAN	☒	E
SK04	ILLUSTRATIVE MASTERPLAN	☒	D
SK05	SITE MOVEMENT STRATEGY	☒	D

CLASSIC DEVELOPMENTS LTD - : SUBDIVISION CONSENT APPLICATION - 2/11/21

WOOLSHED RD MASTERPLAN

Woolshed Road, Jacks Point 9371
RESIDENTIAL MASTERPLAN

© COPYRIGHT RESERVED BY CONSTRUCT ARCHITECTS LTD. The Plan: Nomenclature: CONSTRUCT PROJECT: WOOLSHED RD MASTERPLAN/ARCHITECTS: Maitland: 19/05/2022

QUEENSTOWN LAKES DISTRICT COUNCIL

APPROVED PLAN:

PA1300615

Friday, 29 September 2023

220

Site Area: 145,304 m²

LEGEND

SITE ASSESSMENT

Legal description: Part of Lot 9 DP Lot 9 DP 498179
Address: Woolshed Rd
Site Area: 145,304m²
Zone: Henley zone, Residential

DEVELOPMENT DESCRIPTION

Medium Density Housing Development

PUBLIC

Road
Street berm
Footpath

PRIVATE

Site boundary
Lot boundaries

LOT MIX

KEY	LOT FRONTAGE (m)	NO. OF LOTS	% OF TOTAL
	< (10)	14	5%
	10 < (11)	29	10%
	11 < (12)	78	29%
	12 < (13)	79	30%
	13 < (14)	53	19%
	14 +	19	7%
TOTAL		272	100%

APPROVED PLAN:
RM200615

Friday, 29 September 2023

LEGEND

SITE ASSESSMENT

Legal description:	Part of Lot 9 DP Lot 9 DP 498179
Address:	Woolshed Rd
Site Area:	145,304m ²
Zone:	Henley zone, Residential

DEVELOPMENT DESCRIPTION


Medium Density Housing Development

On street parking	251	0.92 per dwelling
-------------------	-----	-------------------

PUBLIC

	Road
	Street berm
	Footpath
	Street parking
	Street lighting
	Trees

 PRIVATE

	Site boundary
	Lot boundaries
	29 Lot number
	Building
	Driveway
	Site paving
	Soft landscaping

